

注：现场喷淋拆改及空调风管拆改根据专业图纸



江苏省海门市海门路98号光彩大厦
TEL:0513-82213855 FAX:0513-82213857
http://www.zilang.com

紫浪装饰设计
ZI LANG . DESIGNED

海门大剧院文化中心商铺装修设计项目

HA IMEN CHINA

3区（248m²）拆改平面图

ALL DESIGNS AND SPECIFICATIONS ARE THE PROPERTY OF ZI LANG DESIGN LTD. AND CANNOT BE USED WITHOUT THEIR WRITTEN PERMISSION. THE SAME SHALL BE RETURNED UPON COMPLETION OF THE PROJECT. DO NOT SCALE DRAWINGS. ALL MEASUREMENTS MUST BE CHECKED ON SITE BY THE CONTRACTORS AND ANY DISCREPANCIES BROUGHT TO THE ATTENTION OF THE DESIGNER OR ARCHITECT. THIS DRAWING IS TO BE USED FOR THE PROJECT AND SITE IDENTIFIED AND NOT TO BE USED ON ANY OTHER PROJECT.

REVISION DATE

Scale 比例 Date 日期

PS 1:60@A2 PS

Designed BY 设计 Drawn BY 绘图


PS PS

Job NO. 项目编号 APPROVED BY 核准

PS PS

Sheet NO. 图号 页码

3Q-P-01

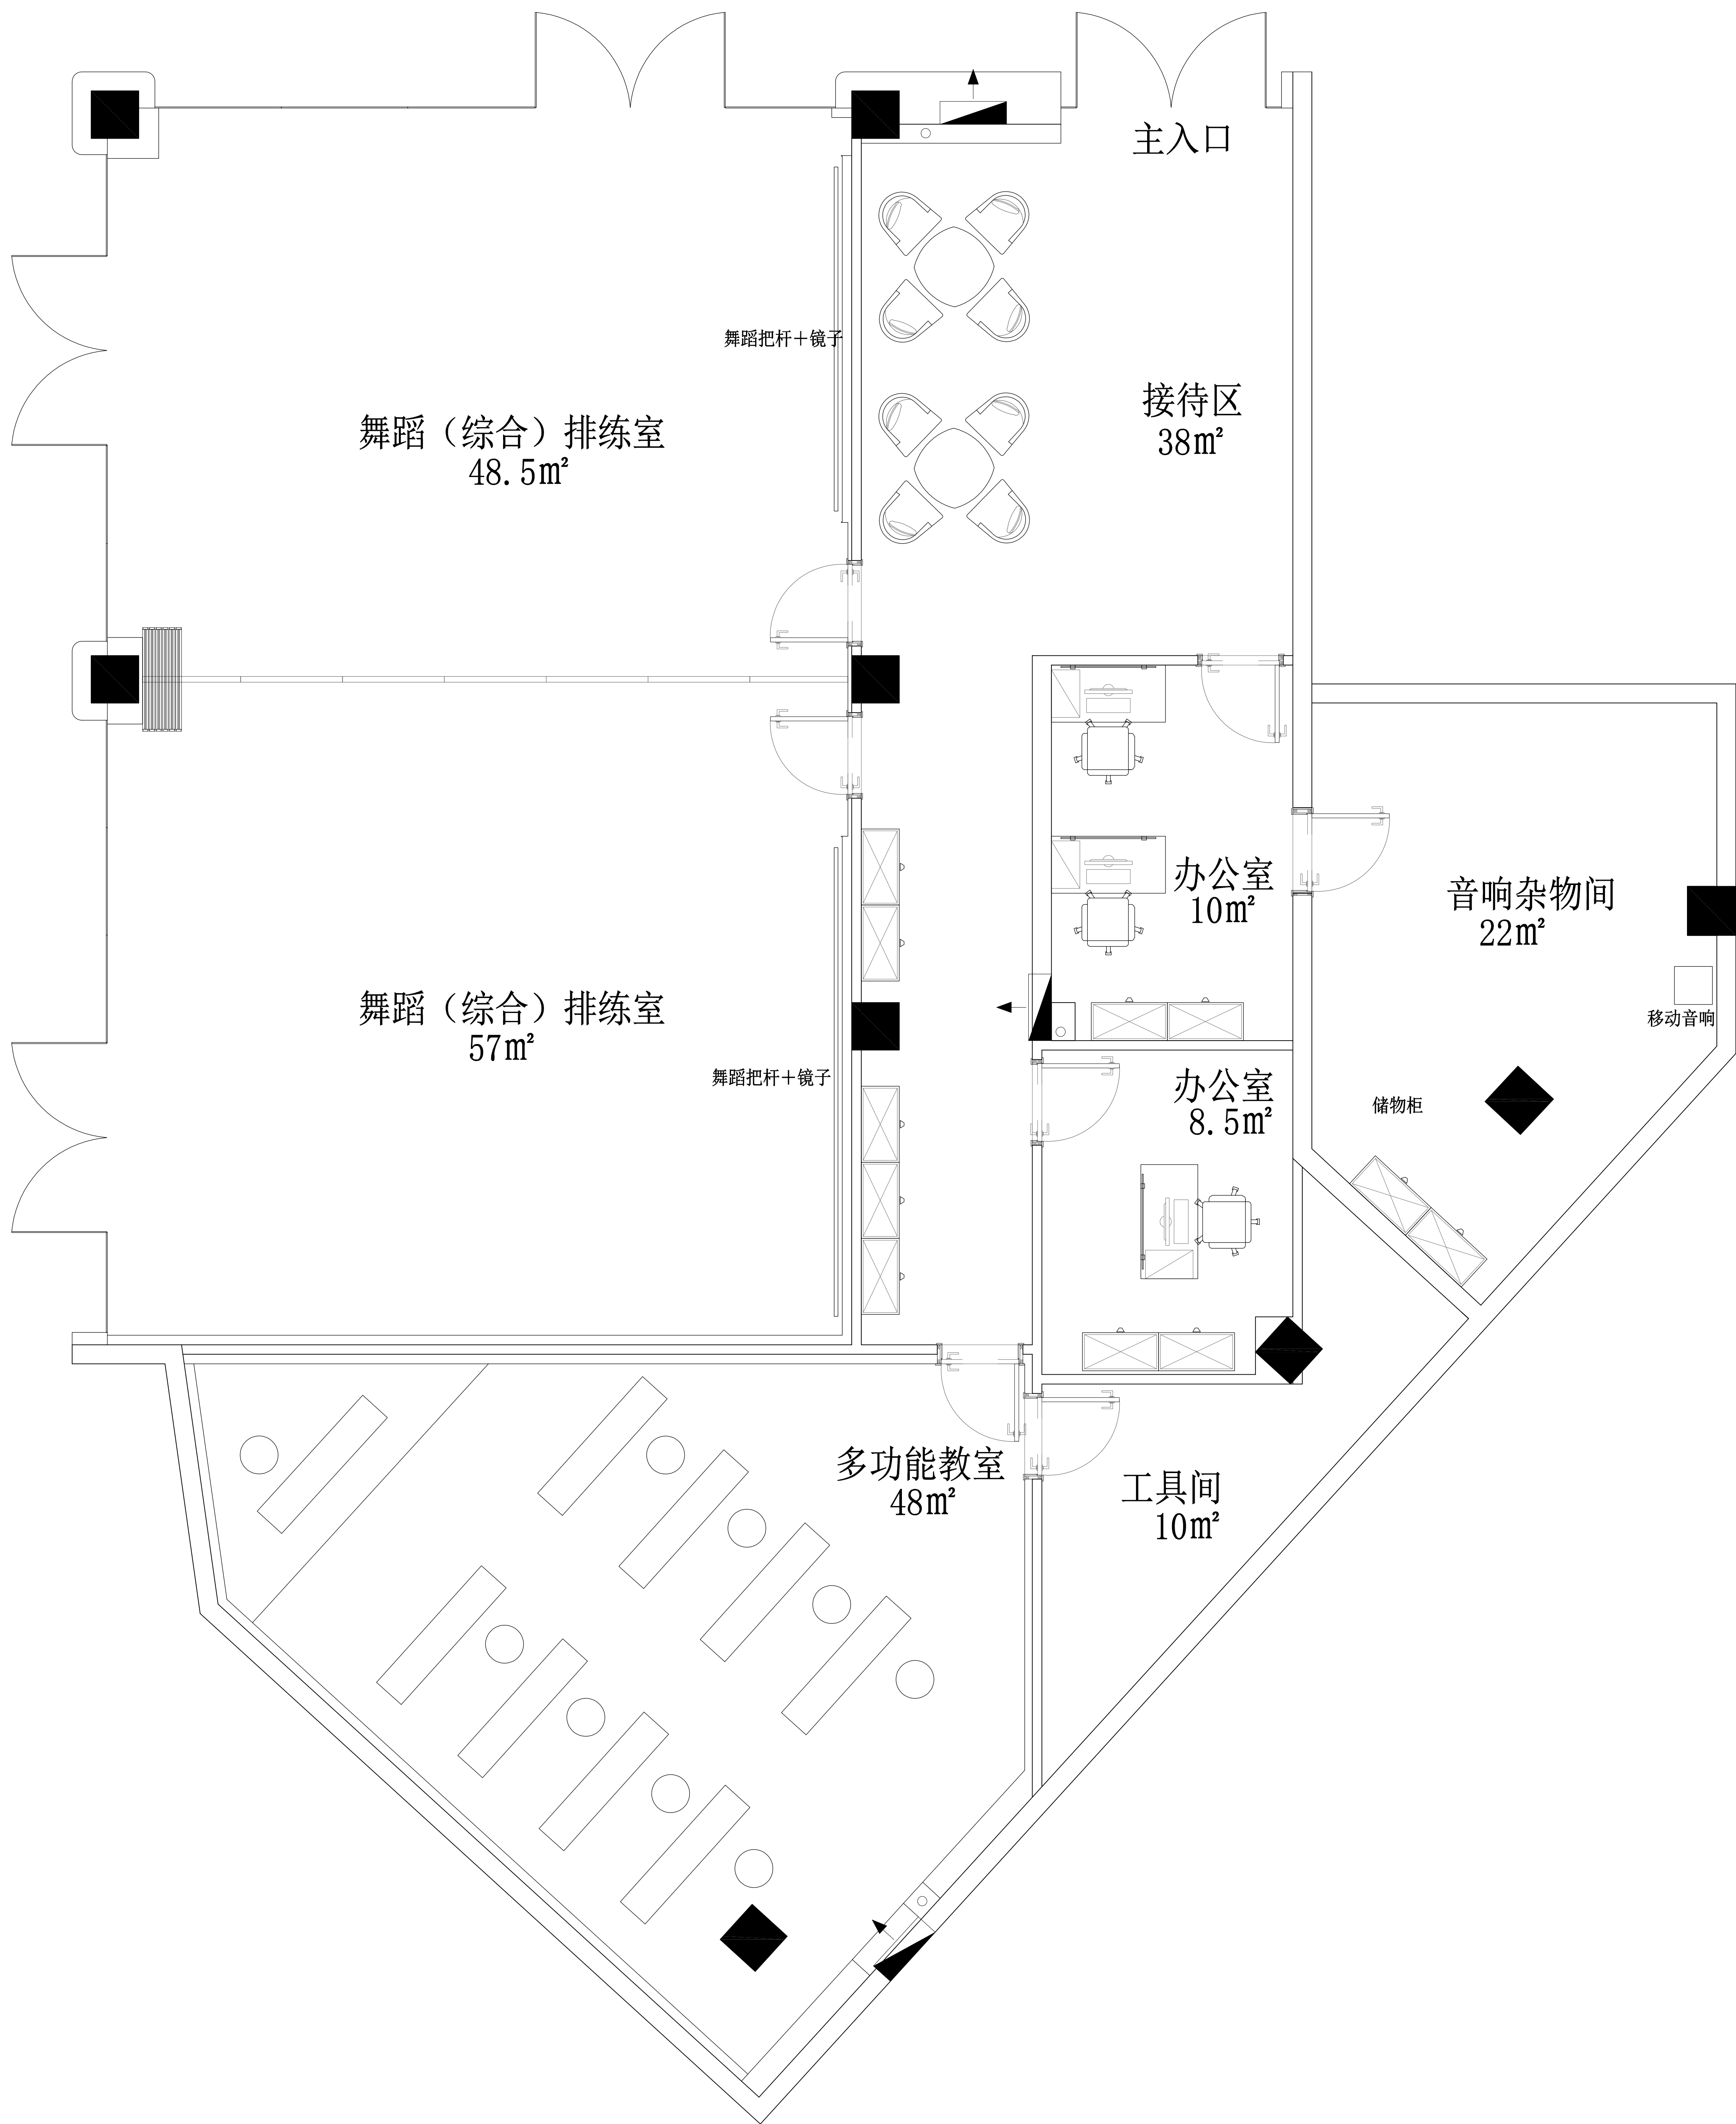

海门大剧院文化中心商铺装修设计项目

CHINA

HAIMEN



ZILANG

江苏海门市海陵路98号光彩大厦
TEL: 0513-86215865 FAX: 0513-86215867
http://www.zilang.com

紫浪装饰设计
ZI LANG . DESIGNED

3区 (248m²) 平面布置图

ALL DESIGNS AND SPECIFICATIONS ARE THE PROPERTY OF ZI LANG DESIGN LTD. AND CANNOT BE USED WITHOUT THEIR WRITTEN PERMISSION. THE SAME SHALL BE RETURNED UPON COMPLETION OF THE PROJECT. DO NOT SCALE DRAWINGS. ALL MEASUREMENTS MUST BE CHECKED ON SITE BY THE CONTRACTORS AND ANY DISCREPANCIES BROUGHT TO THE ATTENTION OF THE DESIGNER OR ARCHITECT. THIS DRAWING IS TO BE USED FOR THE PROJECT AND SITE IDENTIFIED AND NOT TO BE USED ON ANY OTHER PROJECT.

REVISION DATE

Scale 比例 Date 日期

PH 1:60@A2 PH

Designed BY 设计 Drawn BY 绘图

PH PH


Job NO. 项目编号 APPROVED BY 核准

PH PH

Sheet NO. 图号 页码

3Q-P-03

图例	名称	规格/型号
	喷淋头	
	烟感	
	方形出风口	
	方形回风口	600*600
	条形回风口	300*1200
	双头方筒灯	4000K
	LED平板灯	600*600, 4000K
	吸顶定阻音箱	
	400万高清半球	
	应急筒灯	

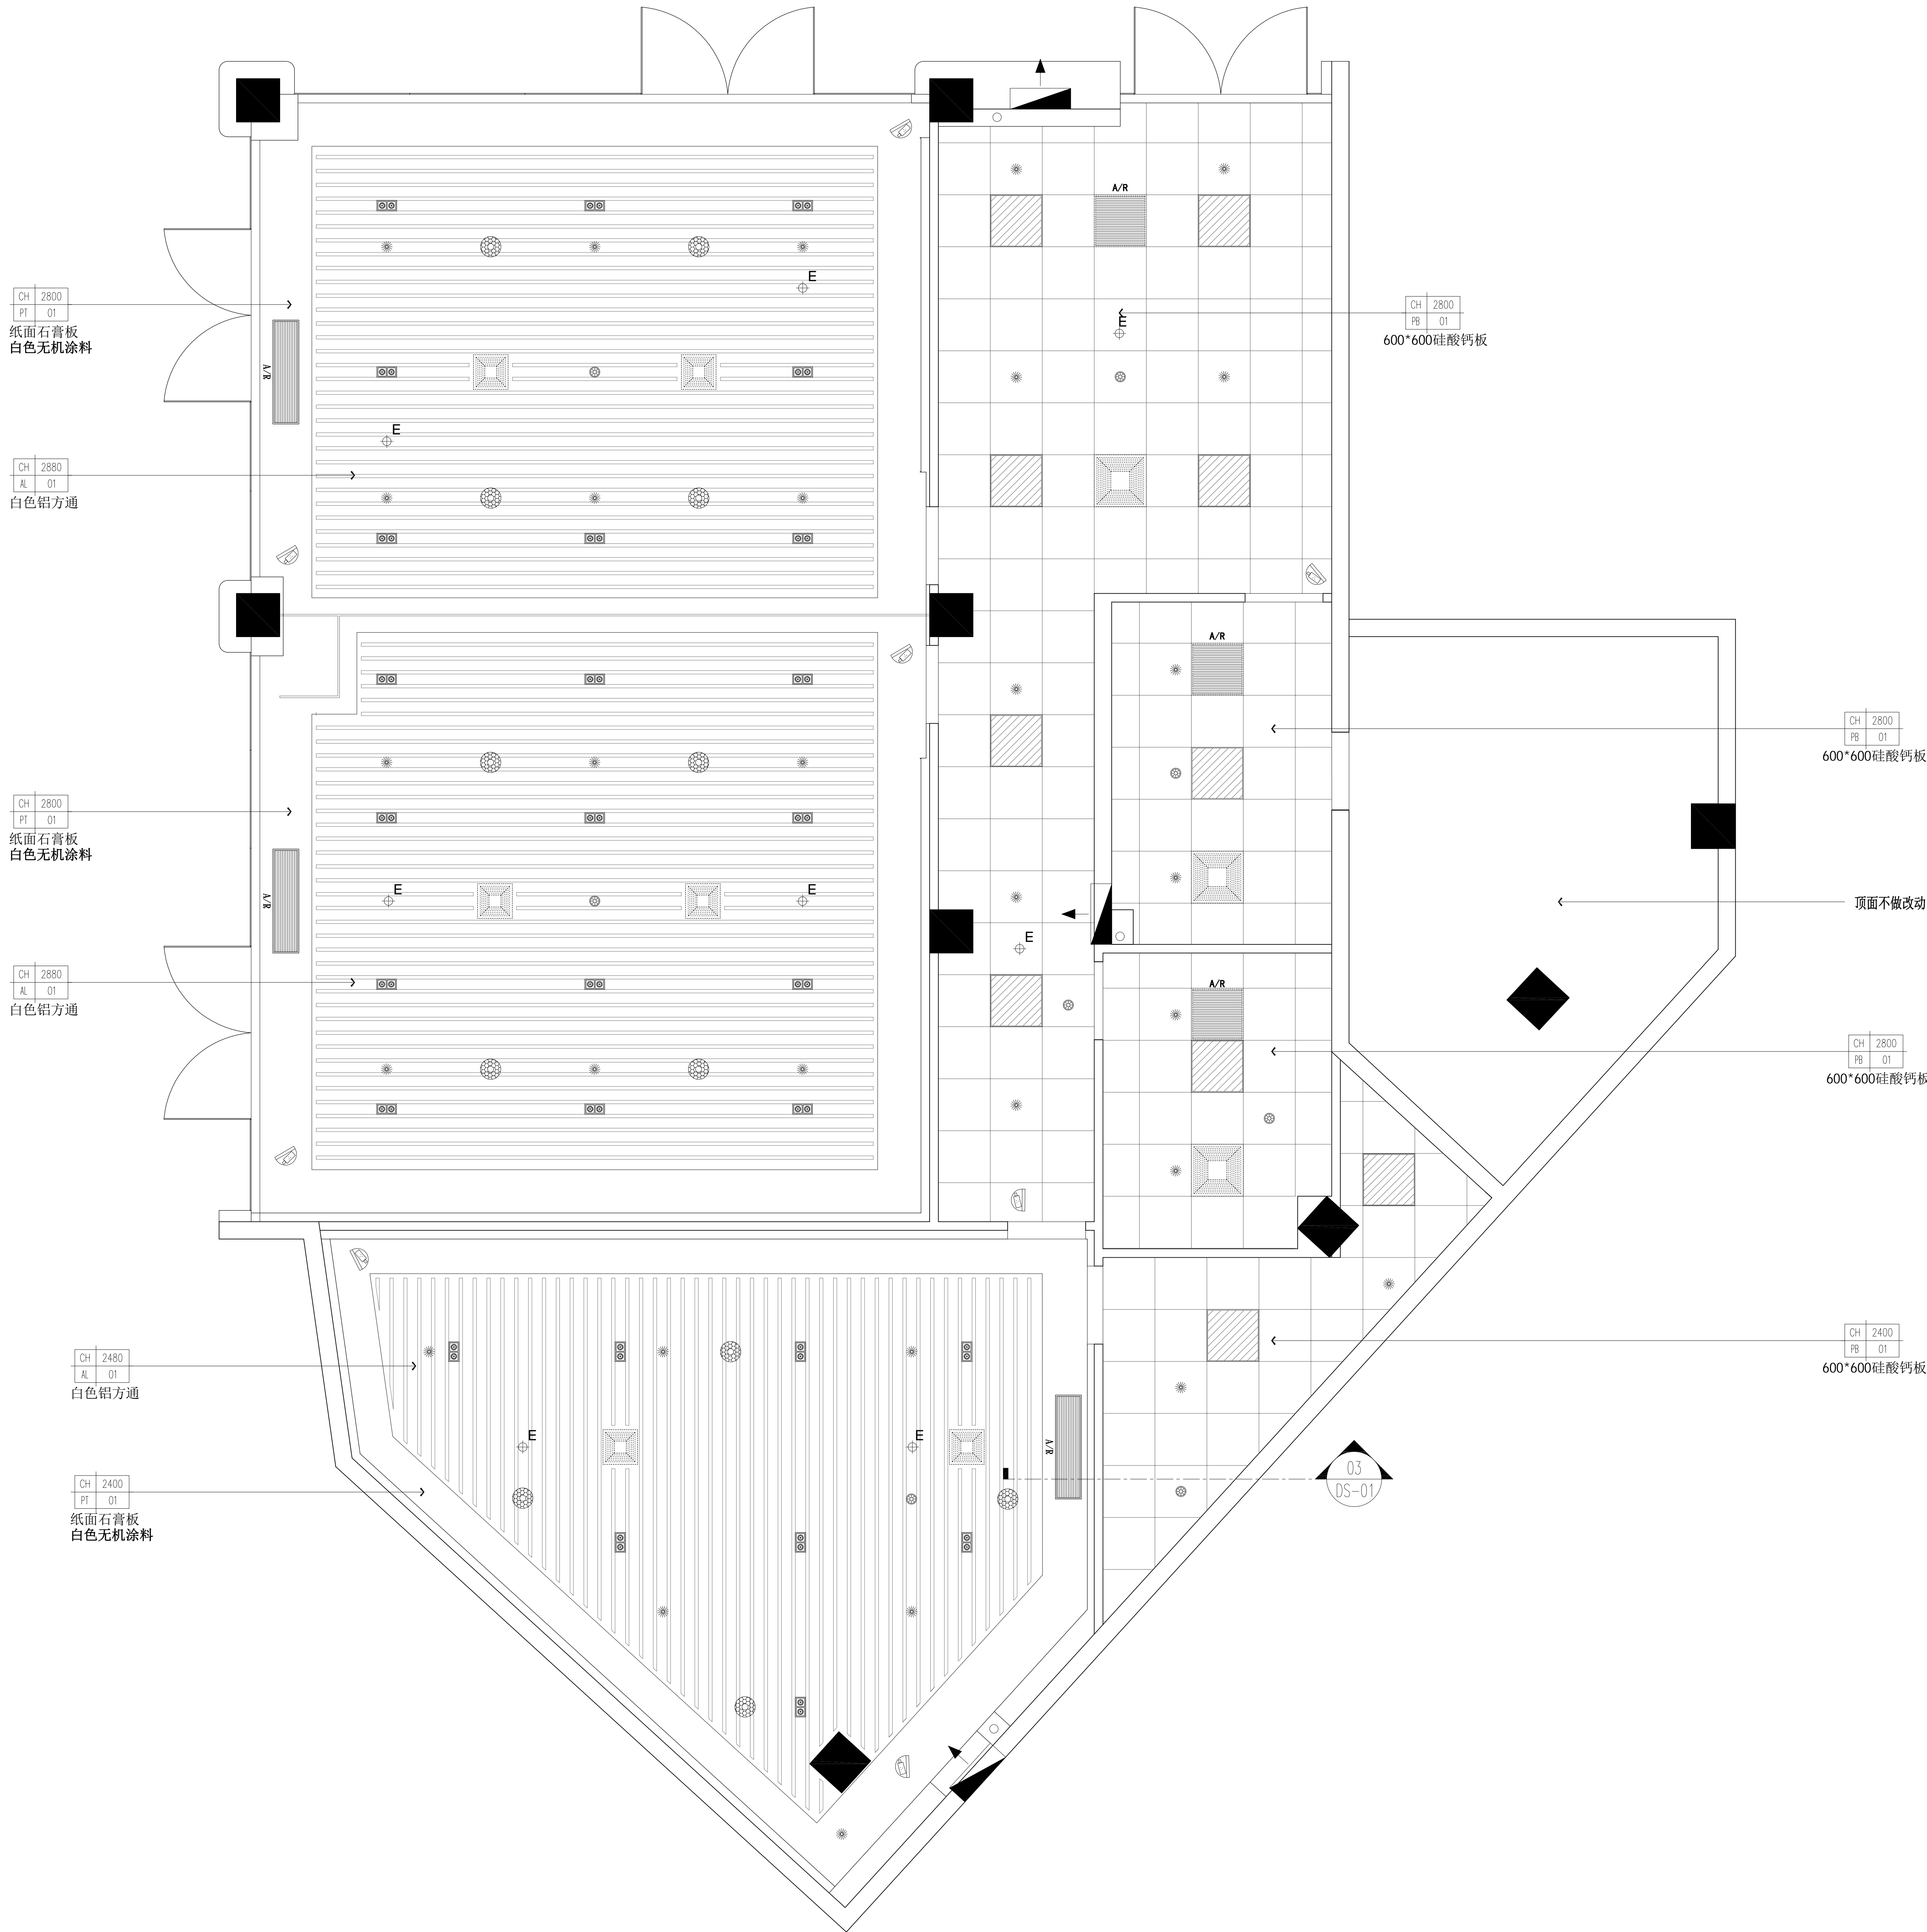

ZI LANG

江苏紫荆门市清静路98号光彩大厦
TEL:0513-86215865 FAX:0513-86215867
http://www.zilang.com

紫浪装饰设计
ZI LANG · DESIGNED

3区（248m²）顶面布置图

DRAWING TITLE

ALL DESIGNS AND SPECIFICATIONS ARE THE PROPERTY OF ZI LANG DESIGN LTD. AND CANNOT BE USED WITHOUT THEIR WRITTEN PERMISSION. THE SAME SHALL BE RETURNED UPON COMPLETION OF THE PROJECT. DO NOT SCALE DRAWINGS. ALL MEASUREMENTS MUST BE CHECKED ON SITE BY THE CONTRACTORS AND ANY DISCREPANCIES BROUGHT TO THE ATTENTION OF THE DESIGNER OR ARCHITECT. THIS DRAWING IS TO BE USED FOR THE PROJECT AND SITE IDENTIFIED AND NOT TO BE USED ON ANY OTHER PROJECT.

REVISION DATE

Scale 比例 Date 日期

PH 1:60@A2 PH
Designed BY 设计 Drawn BY 绘图

PH PH
Job NO. 项目编号 APPROVED BY 核准


PH PH
Sheet NO. 图号 页码

3Q-P-04

海门大剧院文化中心商铺装修设计项目

CHINA

HAIMEN

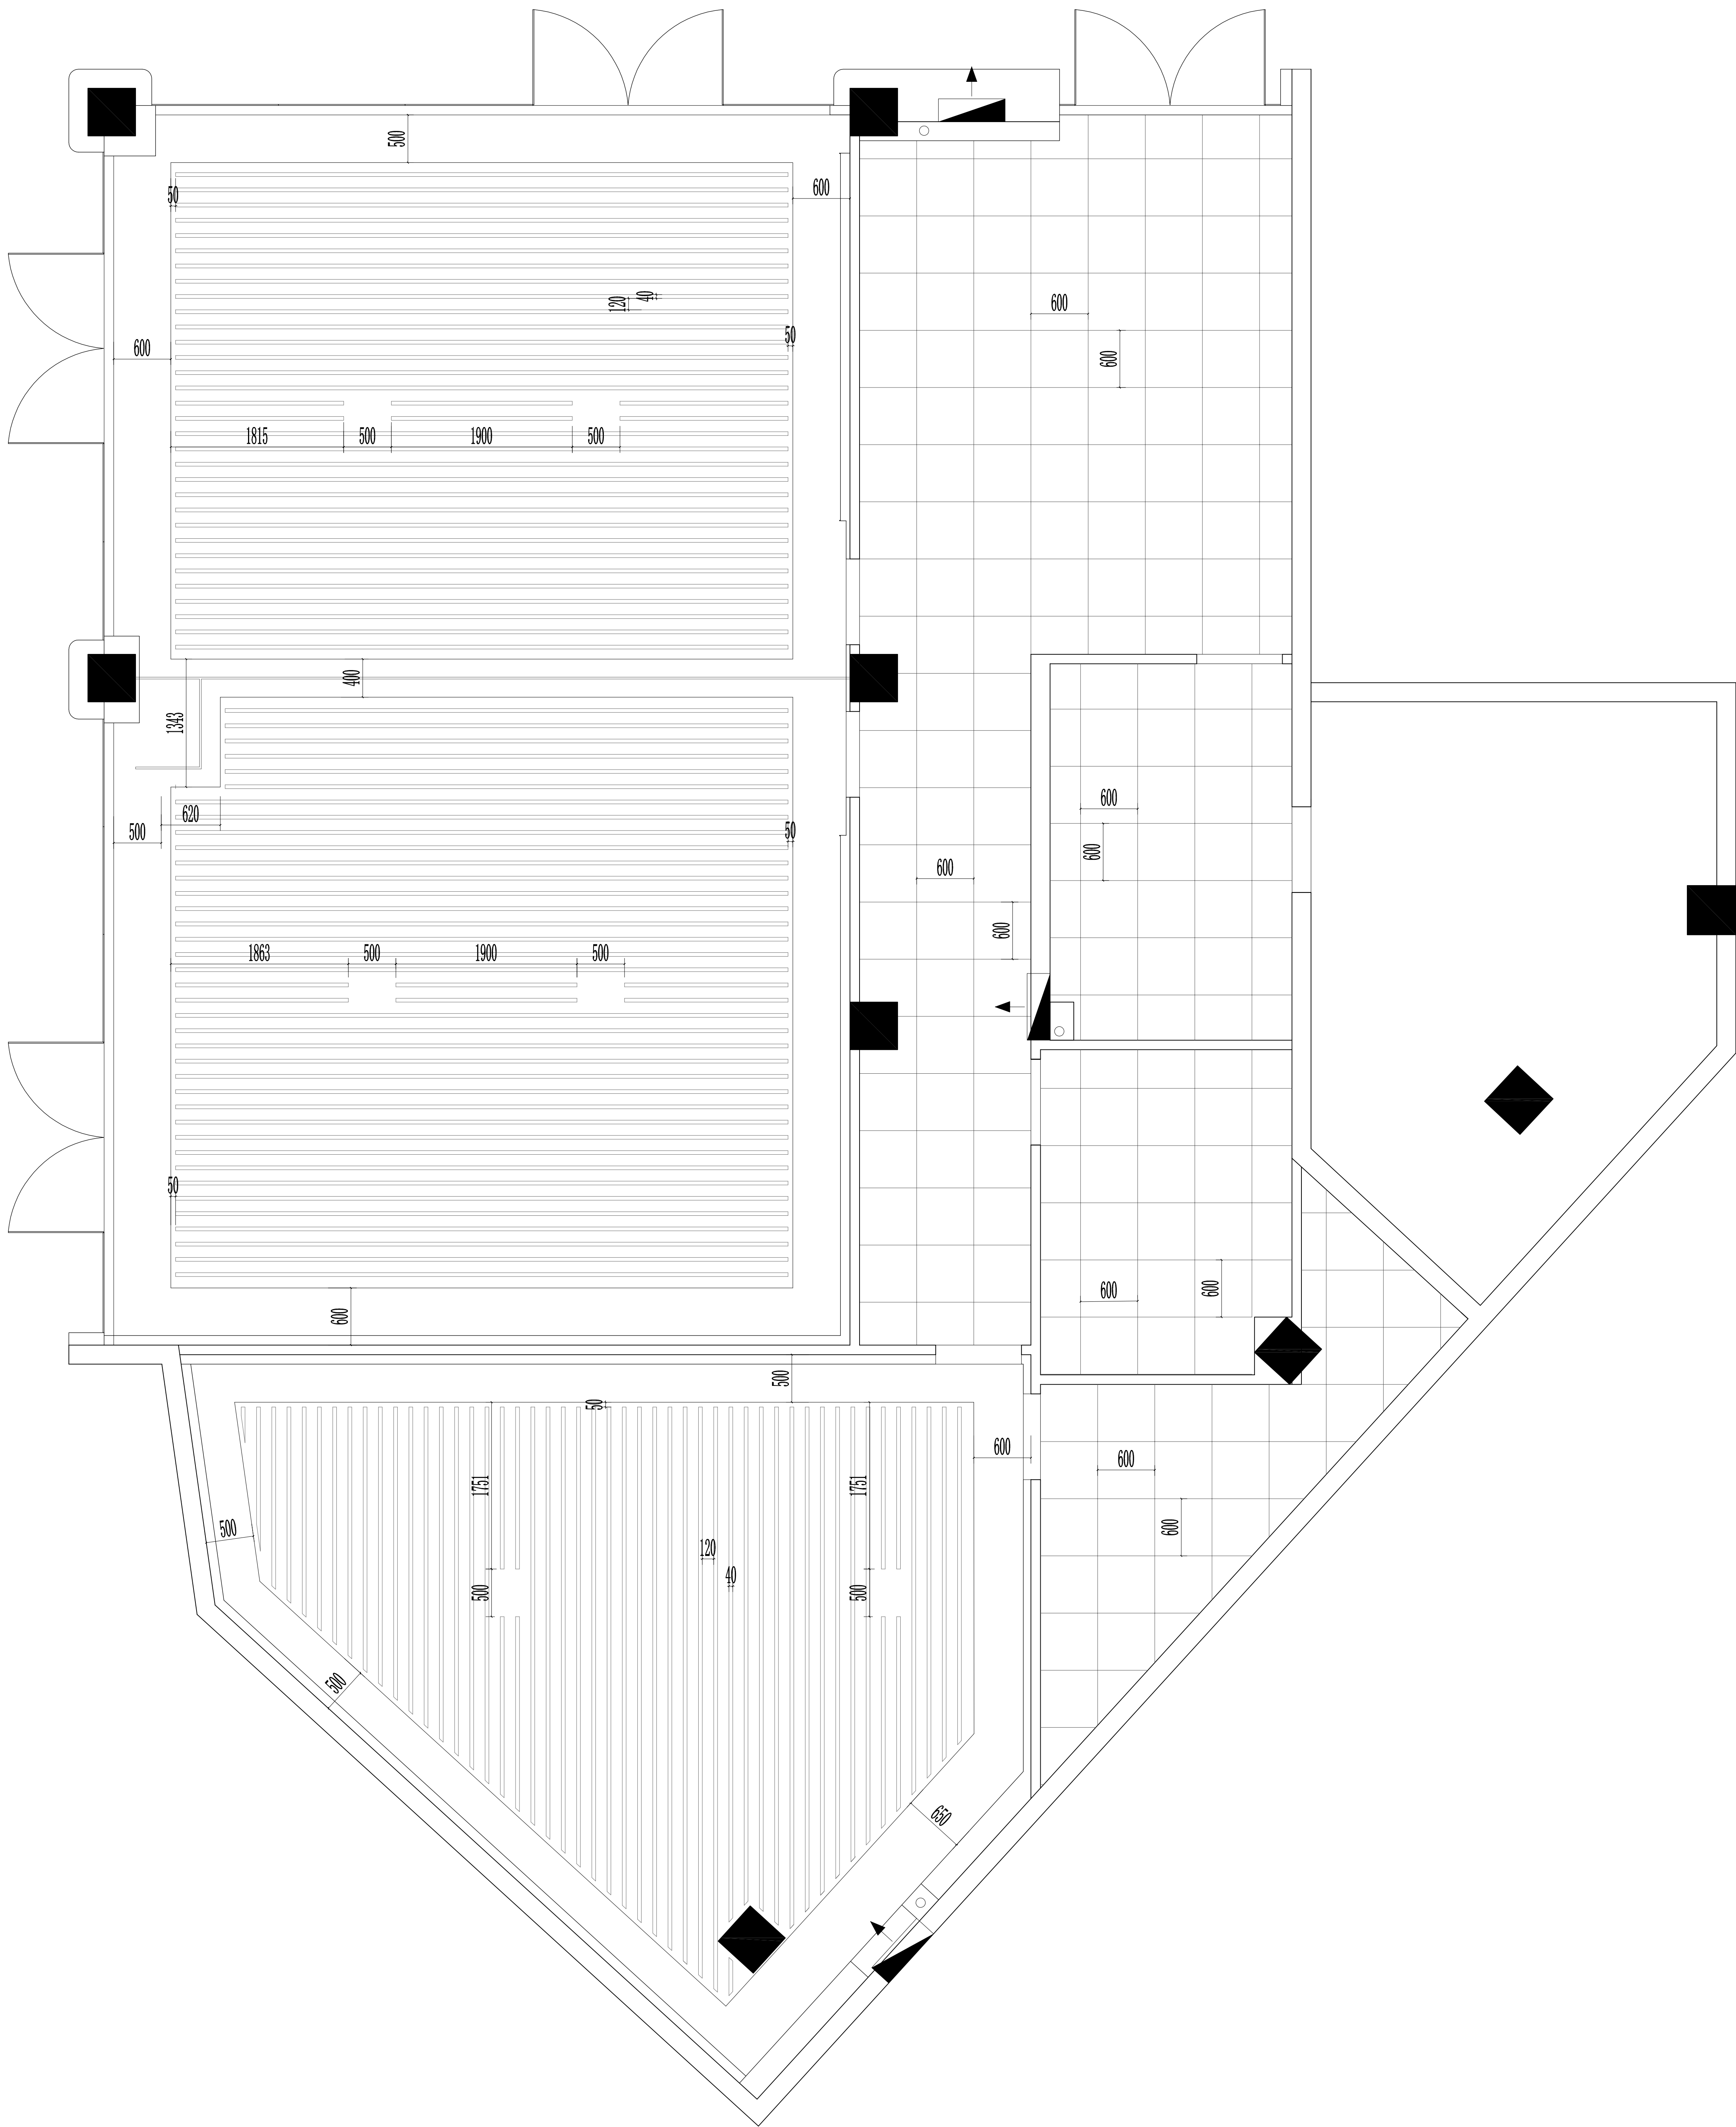

3区（248m²）顶面造型尺寸图

ALL DESIGNS AND SPECIFICATIONS ARE THE PROPERTY OF ZI LANG DESIGN LTD. AND CANNOT BE USED WITHOUT THEIR WRITTEN PERMISSION. THE SAME SHALL BE RETURNED UPON COMPLETION OF THE PROJECT. DO NOT SCALE DRAWINGS. ALL MEASUREMENTS MUST BE CHECKED ON SITE BY THE CONTRACTORS AND ANY DISCREPANCIES BROUGHT TO THE ATTENTION OF THE DESIGNER OR ARCHITECT. THIS DRAWING IS TO BE USED FOR THE PROJECT AND SITE IDENTIFIED AND NOT TO BE USED ON ANY OTHER PROJECT.

REVISION DATE

Scale 比例 Date 日期

PH 1:60@A2 PH

Designed BY 设计 Drawn BY 绘图

PH PH

Job NO. 项目编号 APPROVED BY 核准

PH PH

Sheet NO. 图号 页码

3Q-P-05

海门大剧院文化中心商铺装修设计项目

HA IMEN CHINA



海门大剧院文化中心商铺装修设计项目

HA IMEN CHINA



江苏海门市海陵路98号光彩大厦
TEL:0513-82213853 FAX:0513-82213837
http://www.zilang.com

紫浪装饰设计
ZI LANG . DESIGNED

3区 (248m²) 顶面灯具定位图

DRAWING TITLE

ALL DESIGNS AND SPECIFICATIONS ARE THE PROPERTY OF ZI LANG DESIGN LTD. AND CANNOT BE USED WITHOUT THEIR WRITTEN PERMISSION. THE SAME SHALL BE RETURNED UPON COMPLETION OF THE PROJECT. DO NOT SCALE DRAWINGS. ALL MEASUREMENTS MUST BE CHECKED ON SITE BY THE CONTRACTORS AND ANY DISCREPANCIES BROUGHT TO THE ATTENTION OF THE DESIGNER OR ARCHITECT. THIS DRAWING IS TO BE USED FOR THE PROJECT AND SITE IDENTIFIED AND NOT TO BE USED ON ANY OTHER PROJECT.

REVISION DATE

Scale 比例 Date 日期

PH 1:60@A2 PH
Designed BY 设计 Drawn BY 绘图

PH PH
Job NO. 项目编号 APPROVED BY 核准

PH PH
Sheet NO. 图号 页码

3Q-P-06



江苏海门市海门路98号光彩大厦
TEL:0513-82213853 FAX:0513-82213857
http://www.zilang.com

紫浪装饰设计
ZI LANG . DESIGNED

海门大剧院文化中心商铺装修设计项目

HAIMEN CHINA

3区 (248m²) 消防监控点尺寸图

ALL DESIGNS AND SPECIFICATIONS ARE THE PROPERTY OF ZI LANG DESIGN LTD. AND CANNOT BE USED WITHOUT THEIR WRITTEN PERMISSION. THE SAME SHALL BE RETURNED UPON COMPLETION OF THE PROJECT. DO NOT SCALE DRAWINGS. ALL MEASUREMENTS MUST BE CHECKED ON SITE BY THE CONTRACTORS AND ANY DISCREPANCIES BROUGHT TO THE ATTENTION OF THE DESIGNER OR ARCHITECT. THIS DRAWING IS TO BE USED FOR THE PROJECT AND SITE IDENTIFIED AND NOT TO BE USED ON ANY OTHER PROJECT.

REVISION DATE


Scale 比例 Date 日期

PH 1:60@A2 PH
Designed BY 设计 Drawn BY 绘图

PH PH
Job NO. 项目编号 APPROVED BY 核准

PH PH
Sheet NO. 图号 页码

3Q-P-07

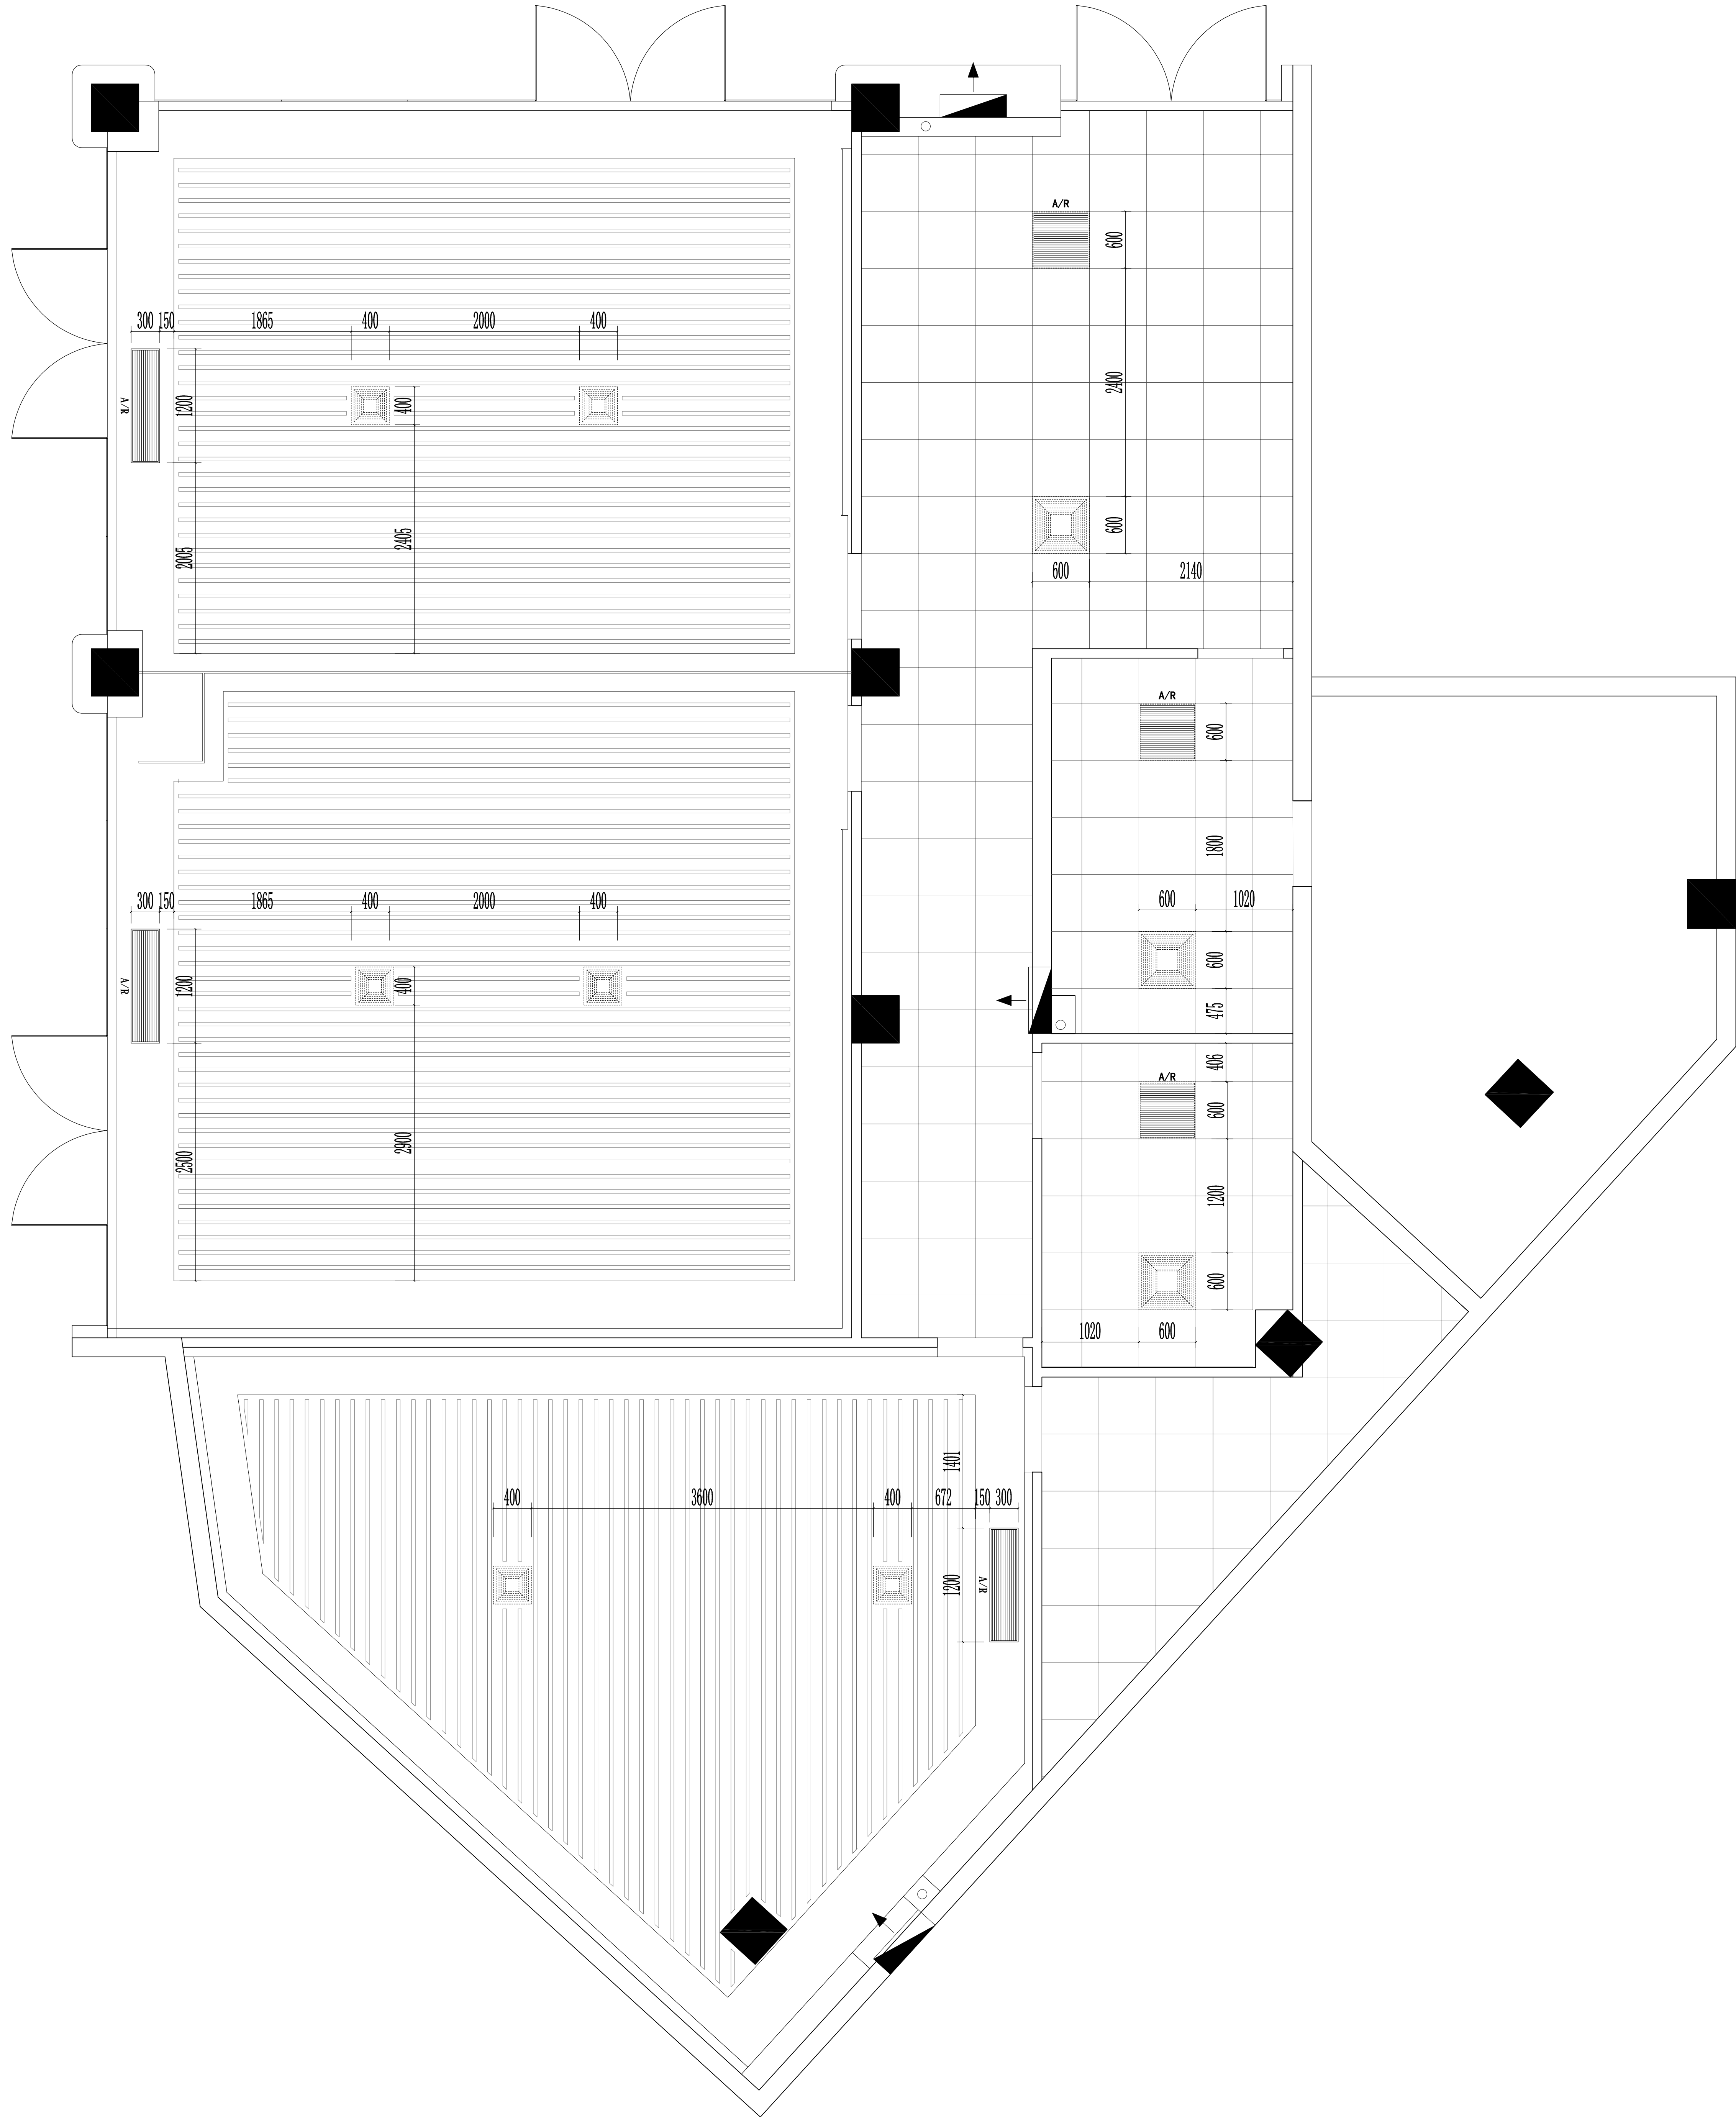

江苏海门市海门路98号光彩大厦
TEL:0513-86215865 FAX:0513-86215867
http://www.zilang.com

紫浪装饰设计
ZI LANG . DESIGNED

海门大剧院文化中心商铺装修设计项目

CHINA

HAIMEN

3区（248m²）空调定位图

DRAWING TITLE

ALL DESIGNS AND SPECIFICATIONS ARE THE PROPERTY OF ZI LANG DESIGN LTD. AND CANNOT BE USED WITHOUT THEIR WRITTEN PERMISSION. THE SAME SHALL BE RETURNED UPON COMPLETION OF THE PROJECT. DO NOT SCALE DRAWINGS. ALL MEASUREMENTS MUST BE CHECKED ON SITE BY THE CONTRACTORS AND ANY DISCREPANCIES BROUGHT TO THE ATTENTION OF THE DESIGNER OR ARCHITECT. THIS DRAWING IS TO BE USED FOR THE PROJECT AND SITE IDENTIFIED AND NOT TO BE USED ON ANY OTHER PROJECT.

REVISION DATE

Scale 比例 Date 日期


PH 1:60@A2 PH
Designed BY 设计 PH Drawn BY 绘图

PH
Job NO. 项目编号 APPROVED BY 核准

PH
Sheet NO. 图号 PH 页码

3Q-P-08

注：所有门槛石均为ST-01。
门槛石与木地板衔接处加金属分嵌线。

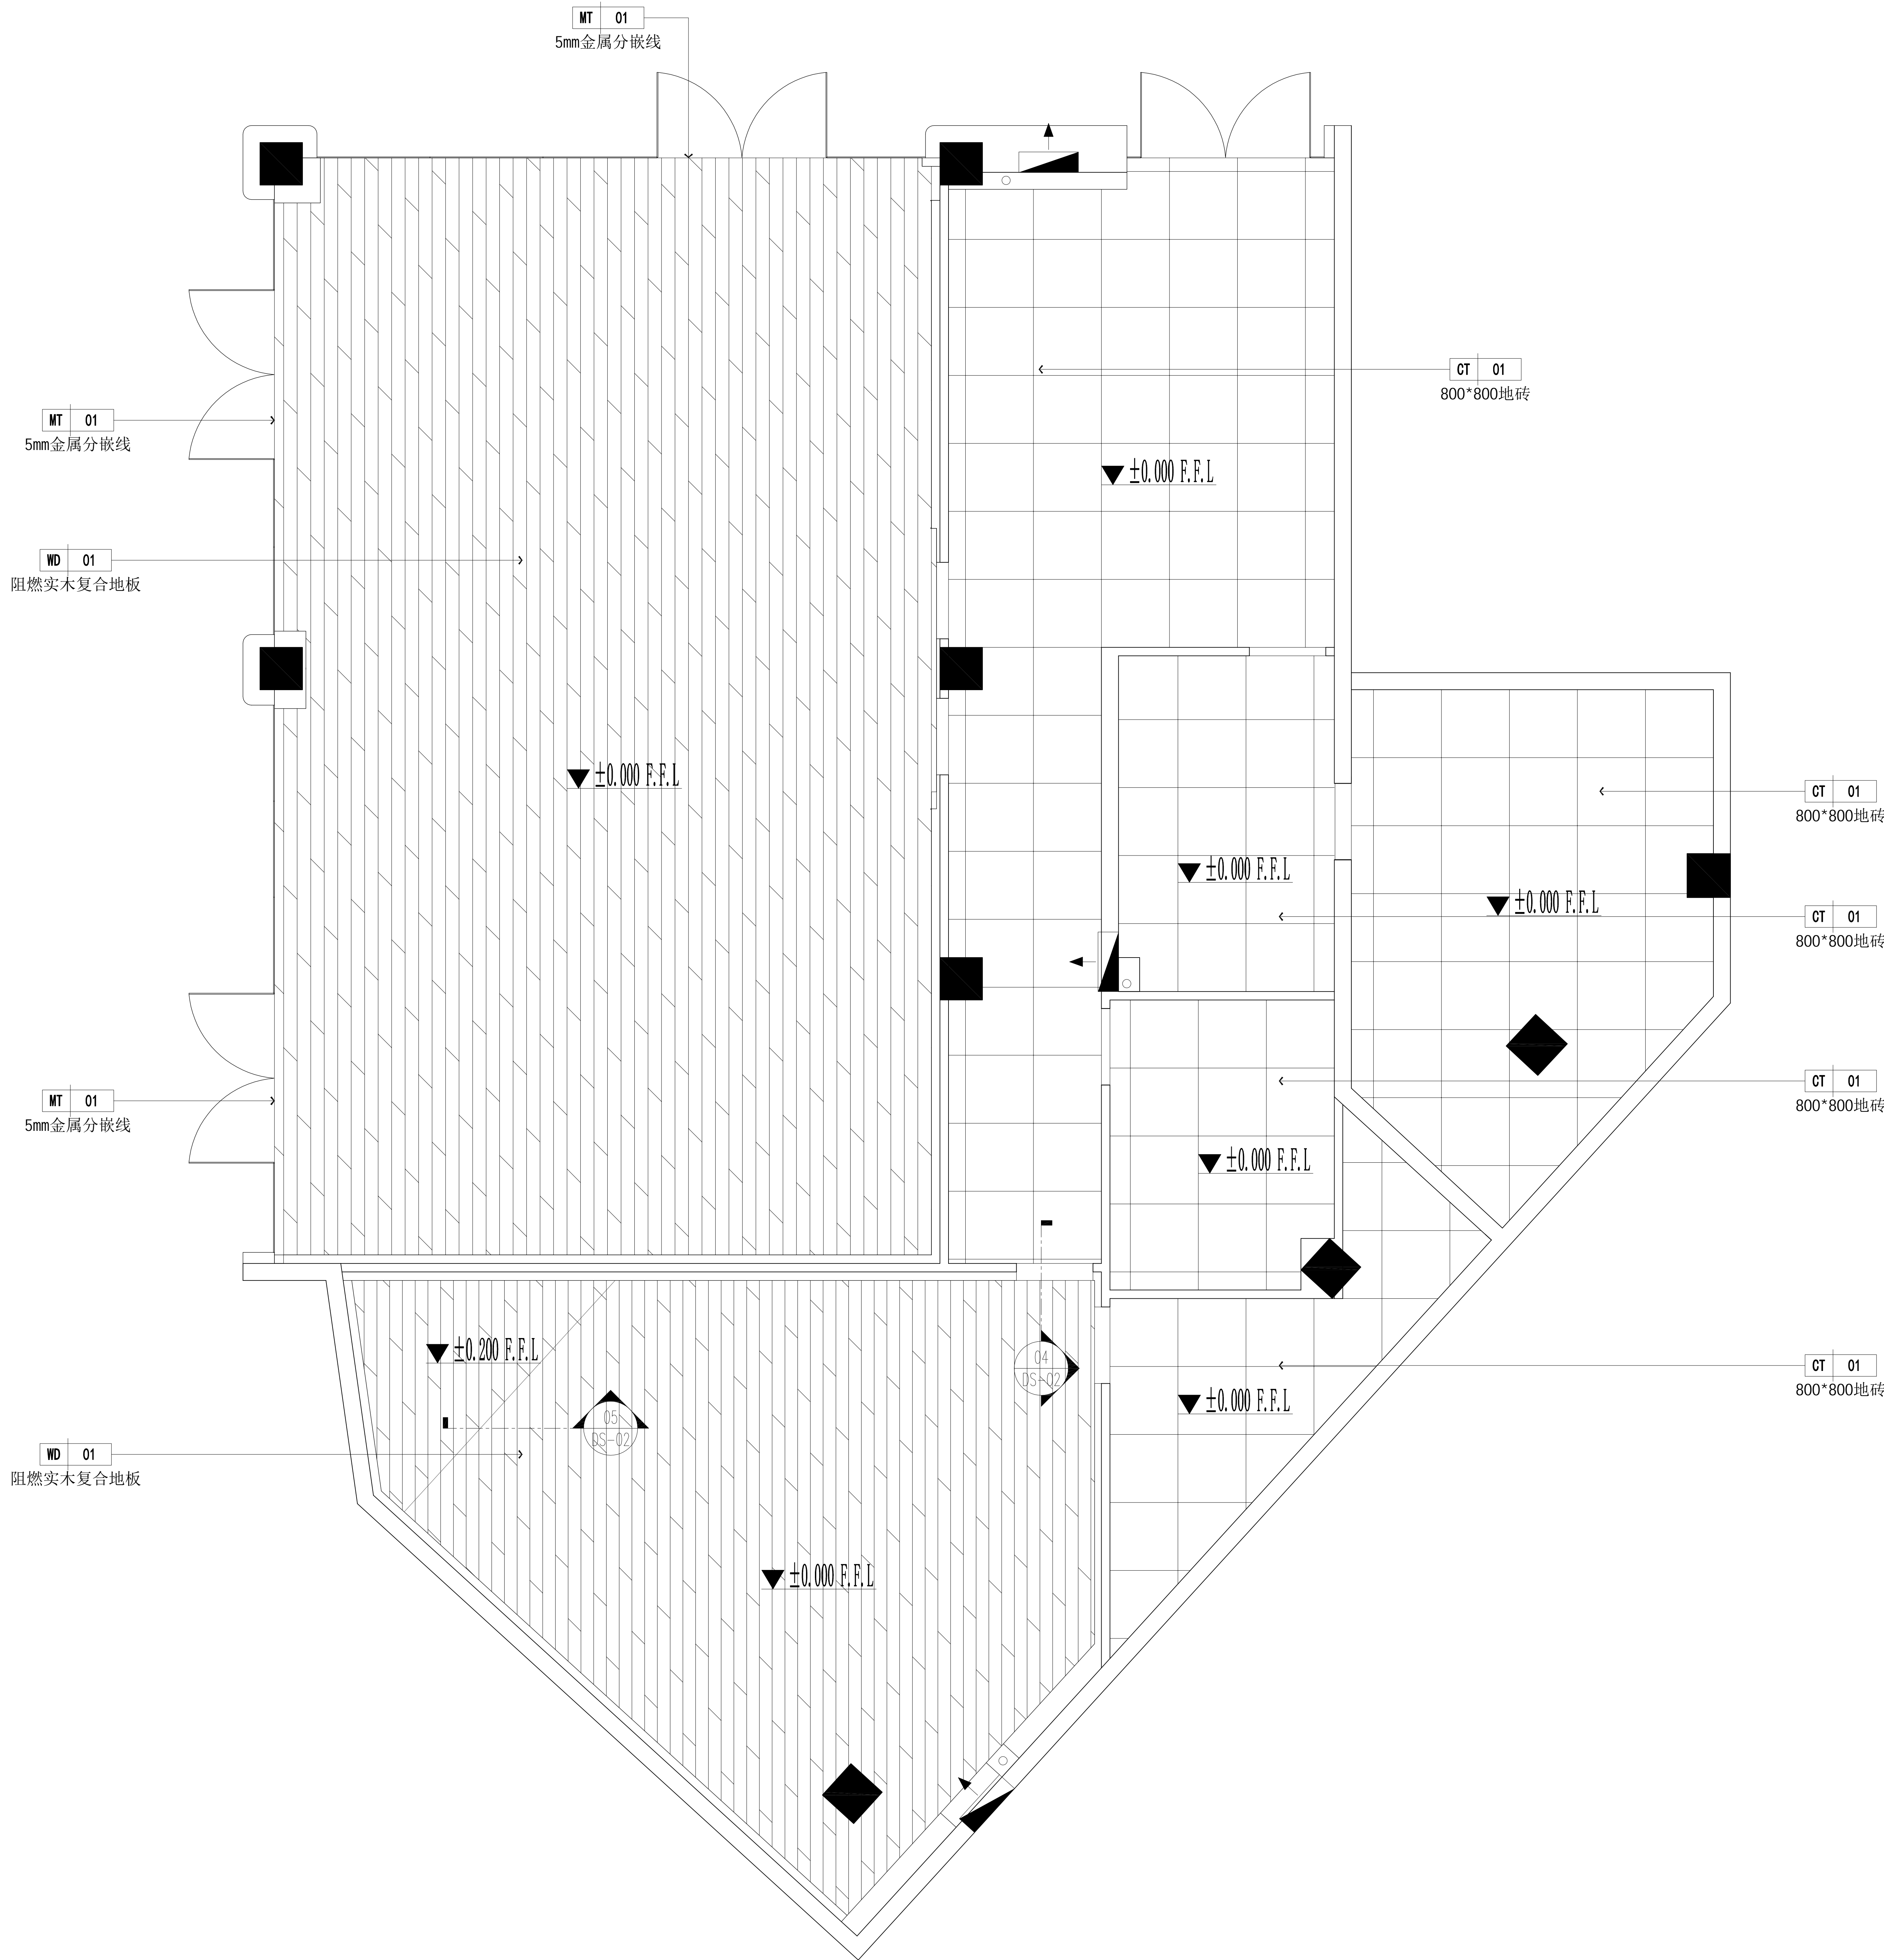

ZI LANG

江苏紫阳门饰装饰工程有限公司
Jiangsu Ziyang Menswear Co., Ltd.
http://www.zi-lang.com

紫浪装饰设计
ZI LANG . DESIGNED

海门大剧院文化中心商铺装修设计项目

CHINA

HA IMEN

3区（248m²）地面铺装图

DRAWING TITLE

ALL DESIGNS AND SPECIFICATIONS ARE THE PROPERTY OF ZI LANG DESIGN LTD. AND CANNOT BE USED WITHOUT THEIR WRITTEN PERMISSION. THE SAME SHALL BE RETURNED UPON COMPLETION OF THE PROJECT. DO NOT SCALE DRAWINGS. ALL MEASUREMENTS MUST BE CHECKED ON SITE BY THE CONTRACTORS AND ANY DISCREPANCIES BROUGHT TO THE ATTENTION OF THE DESIGNER OR ARCHITECT. THIS DRAWING IS TO BE USED FOR THE PROJECT AND SITE IDENTIFIED AND NOT TO BE USED ON ANY OTHER PROJECT.

REVISION DATE

Scale 比例 Date 日期

PH 1:60@A2

Designed BY 设计 PH Drawn BY 绘图

PH Job NO. 项目编号 APPROVED BY 核准


PH Sheet NO. 图号 PH 页码

3Q-P-09

海门大剧院文化中心商铺装修设计项目

CHINA

HAIMEN

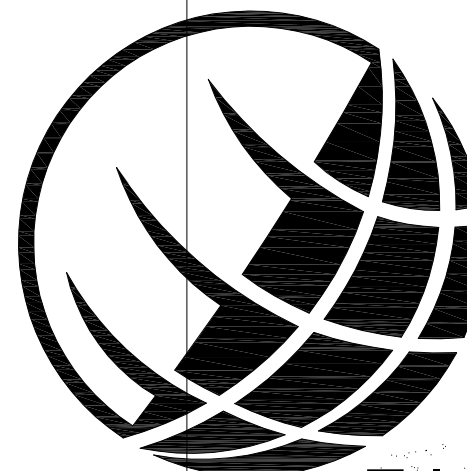

ZI LANG

江苏海门市海门路98号光彩大厦
TEL: 0513-86218865 FAX: 0513-86218867
http://www.zilang.com
紫浪装饰设计
ZI LANG . DESIGNED

3区 (248m²) 立面索引图

DRAWING TITLE

ALL DESIGNS AND SPECIFICATIONS ARE THE PROPERTY OF ZI LANG DESIGN LTD. AND CANNOT BE USED WITHOUT THEIR WRITTEN PERMISSION. THE SAME SHALL BE RETURNED UPON COMPLETION OF THE PROJECT. DO NOT SCALE DRAWINGS. ALL MEASUREMENTS MUST BE CHECKED ON SITE BY THE CONTRACTORS AND ANY DISCREPANCIES BROUGHT TO THE ATTENTION OF THE DESIGNER OR ARCHITECT. THIS DRAWING IS TO BE USED FOR THE PROJECT AND SITE IDENTIFIED AND NOT TO BE USED ON ANY OTHER PROJECT.

REVISION DATE

Scale 比例 Date 日期

PH 1:60@A2 PH
Designed BY 设计 Drawn BY 绘图

PH PH
Job NO. 项目编号 APPROVED BY 核准

PH PH
Sheet NO. 图号 页码

3Q-P-12

