


注：现场喷淋拆改及空调风管拆改根据专业图纸

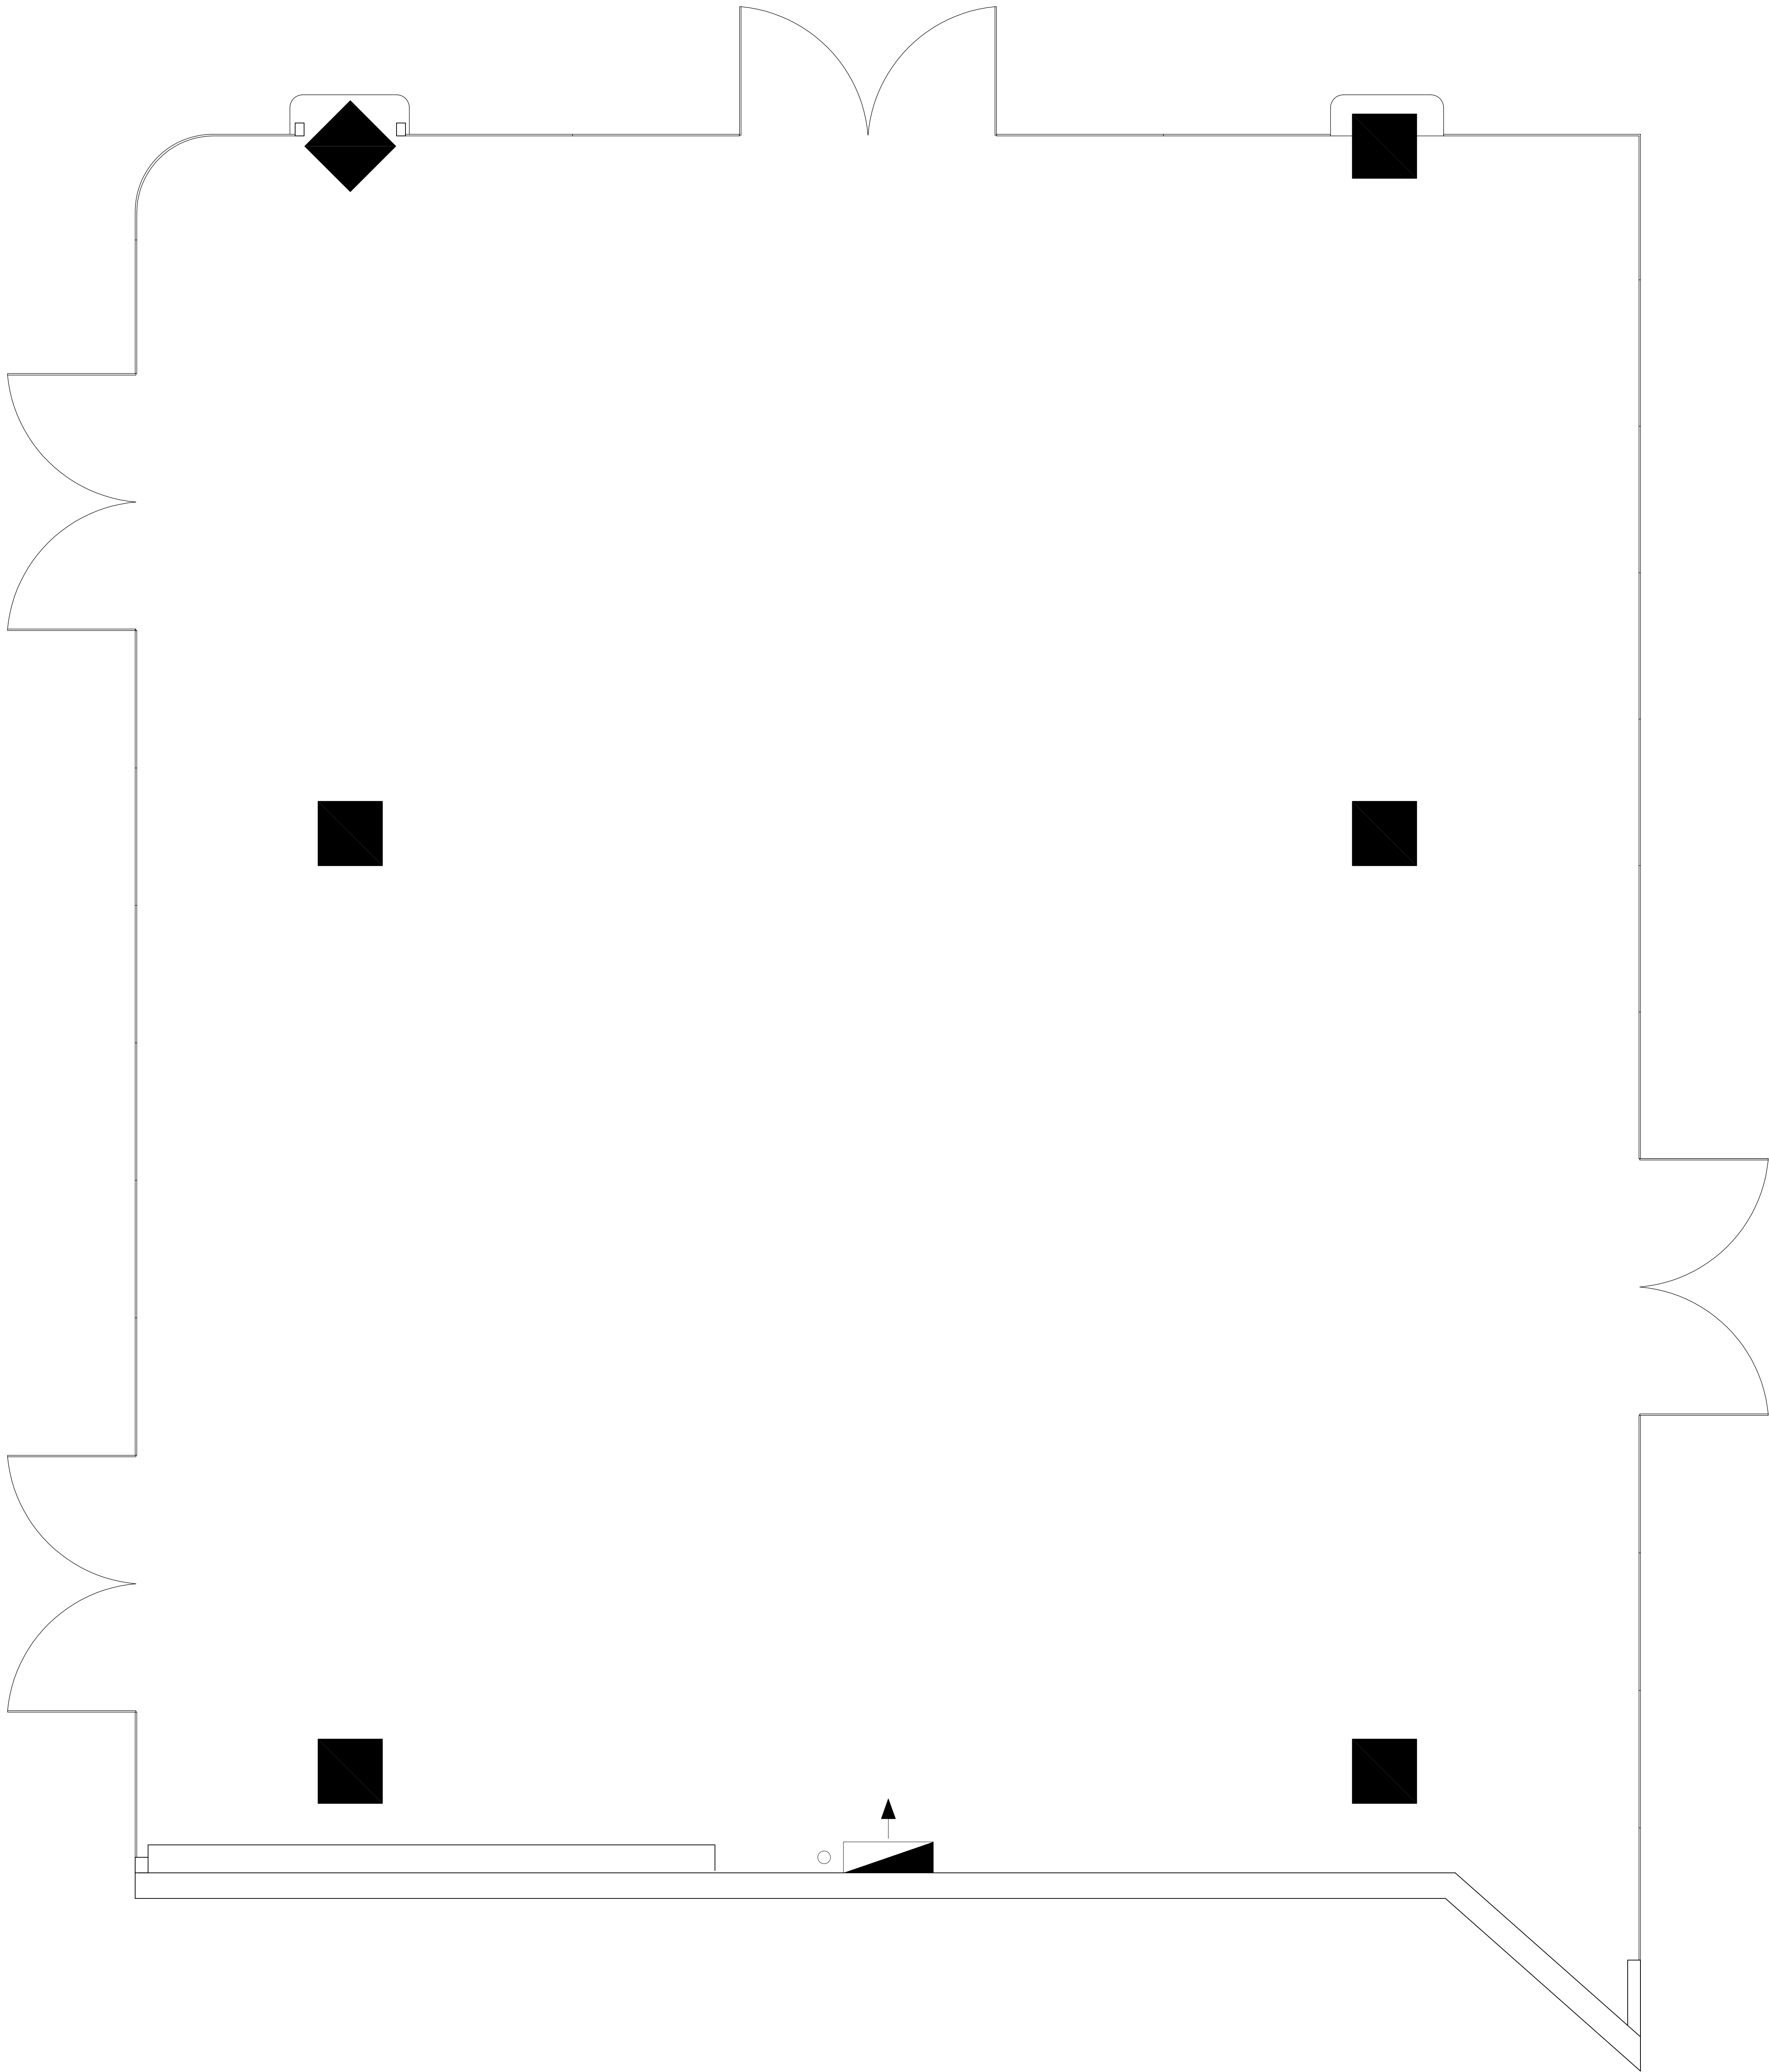

ZILANG

江苏省海门市海陵路98号光彩大厦
TEL:0513-82118850 FAX:0513-82118877
http://www.jiazai.cn

紫浪装饰设计
ZI LANG . DESIGNED

4区（157m²）原始平面图

ALL DESIGNS AND SPECIFICATIONS ARE THE PROPERTY OF
ZI LANG DESIGN LTD. AND CANNOT BE USED WITHOUT
THEIR WRITTEN PERMISSION. THE SAME SHALL BE RETURNED
UPON COMPLETION OF THE PROJECT. DO NOT SCALE DRAWINGS.
ALL MEASUREMENTS MUST BE CHECKED ON SITE BY
THE CONTRACTORS AND ANY DISCREPANCIES BROUGHT
TO THE ATTENTION OF THE DESIGNER OR ARCHITECT.
THIS DRAWING IS TO BE USED FOR THE PROJECT AND SITE
IDENTIFIED AND NOT TO BE USED ON ANY OTHER PROJECT.

REVISION	DATE
----------	------

Scale	比例	Date	日期
-------	----	------	----

PH	1:60@A2	PH	
Designed BY	设计	Drawn BY	绘图

PH	PH		
Job NO.	项目编号	APPROVED BY	核准

PH	PH		
Sheet NO.	图号	页码	

4Q-P-01


海门大剧院文化中心商铺装修设计项目

HA IMEN

CHINA

轻钢龙骨隔墙

- 注：门洞高度为2400mm。
1. 轻钢龙骨隔墙转角处及端头加一根竖向40*40*3mm镀锌方管加固。隔3m左右加竖向40*40*3mm镀锌方管加固。
- 所有门洞两侧加竖向40*40*3mm镀锌方管加固。详见门表大样图。
- 轻钢龙骨隔墙3000mm高度处加横向40*40*3mm镀锌方管加固。
2. 所有石膏板隔墙为12mm石膏板+75轻钢龙骨填100kg/m³岩棉+12mm纸面石膏板

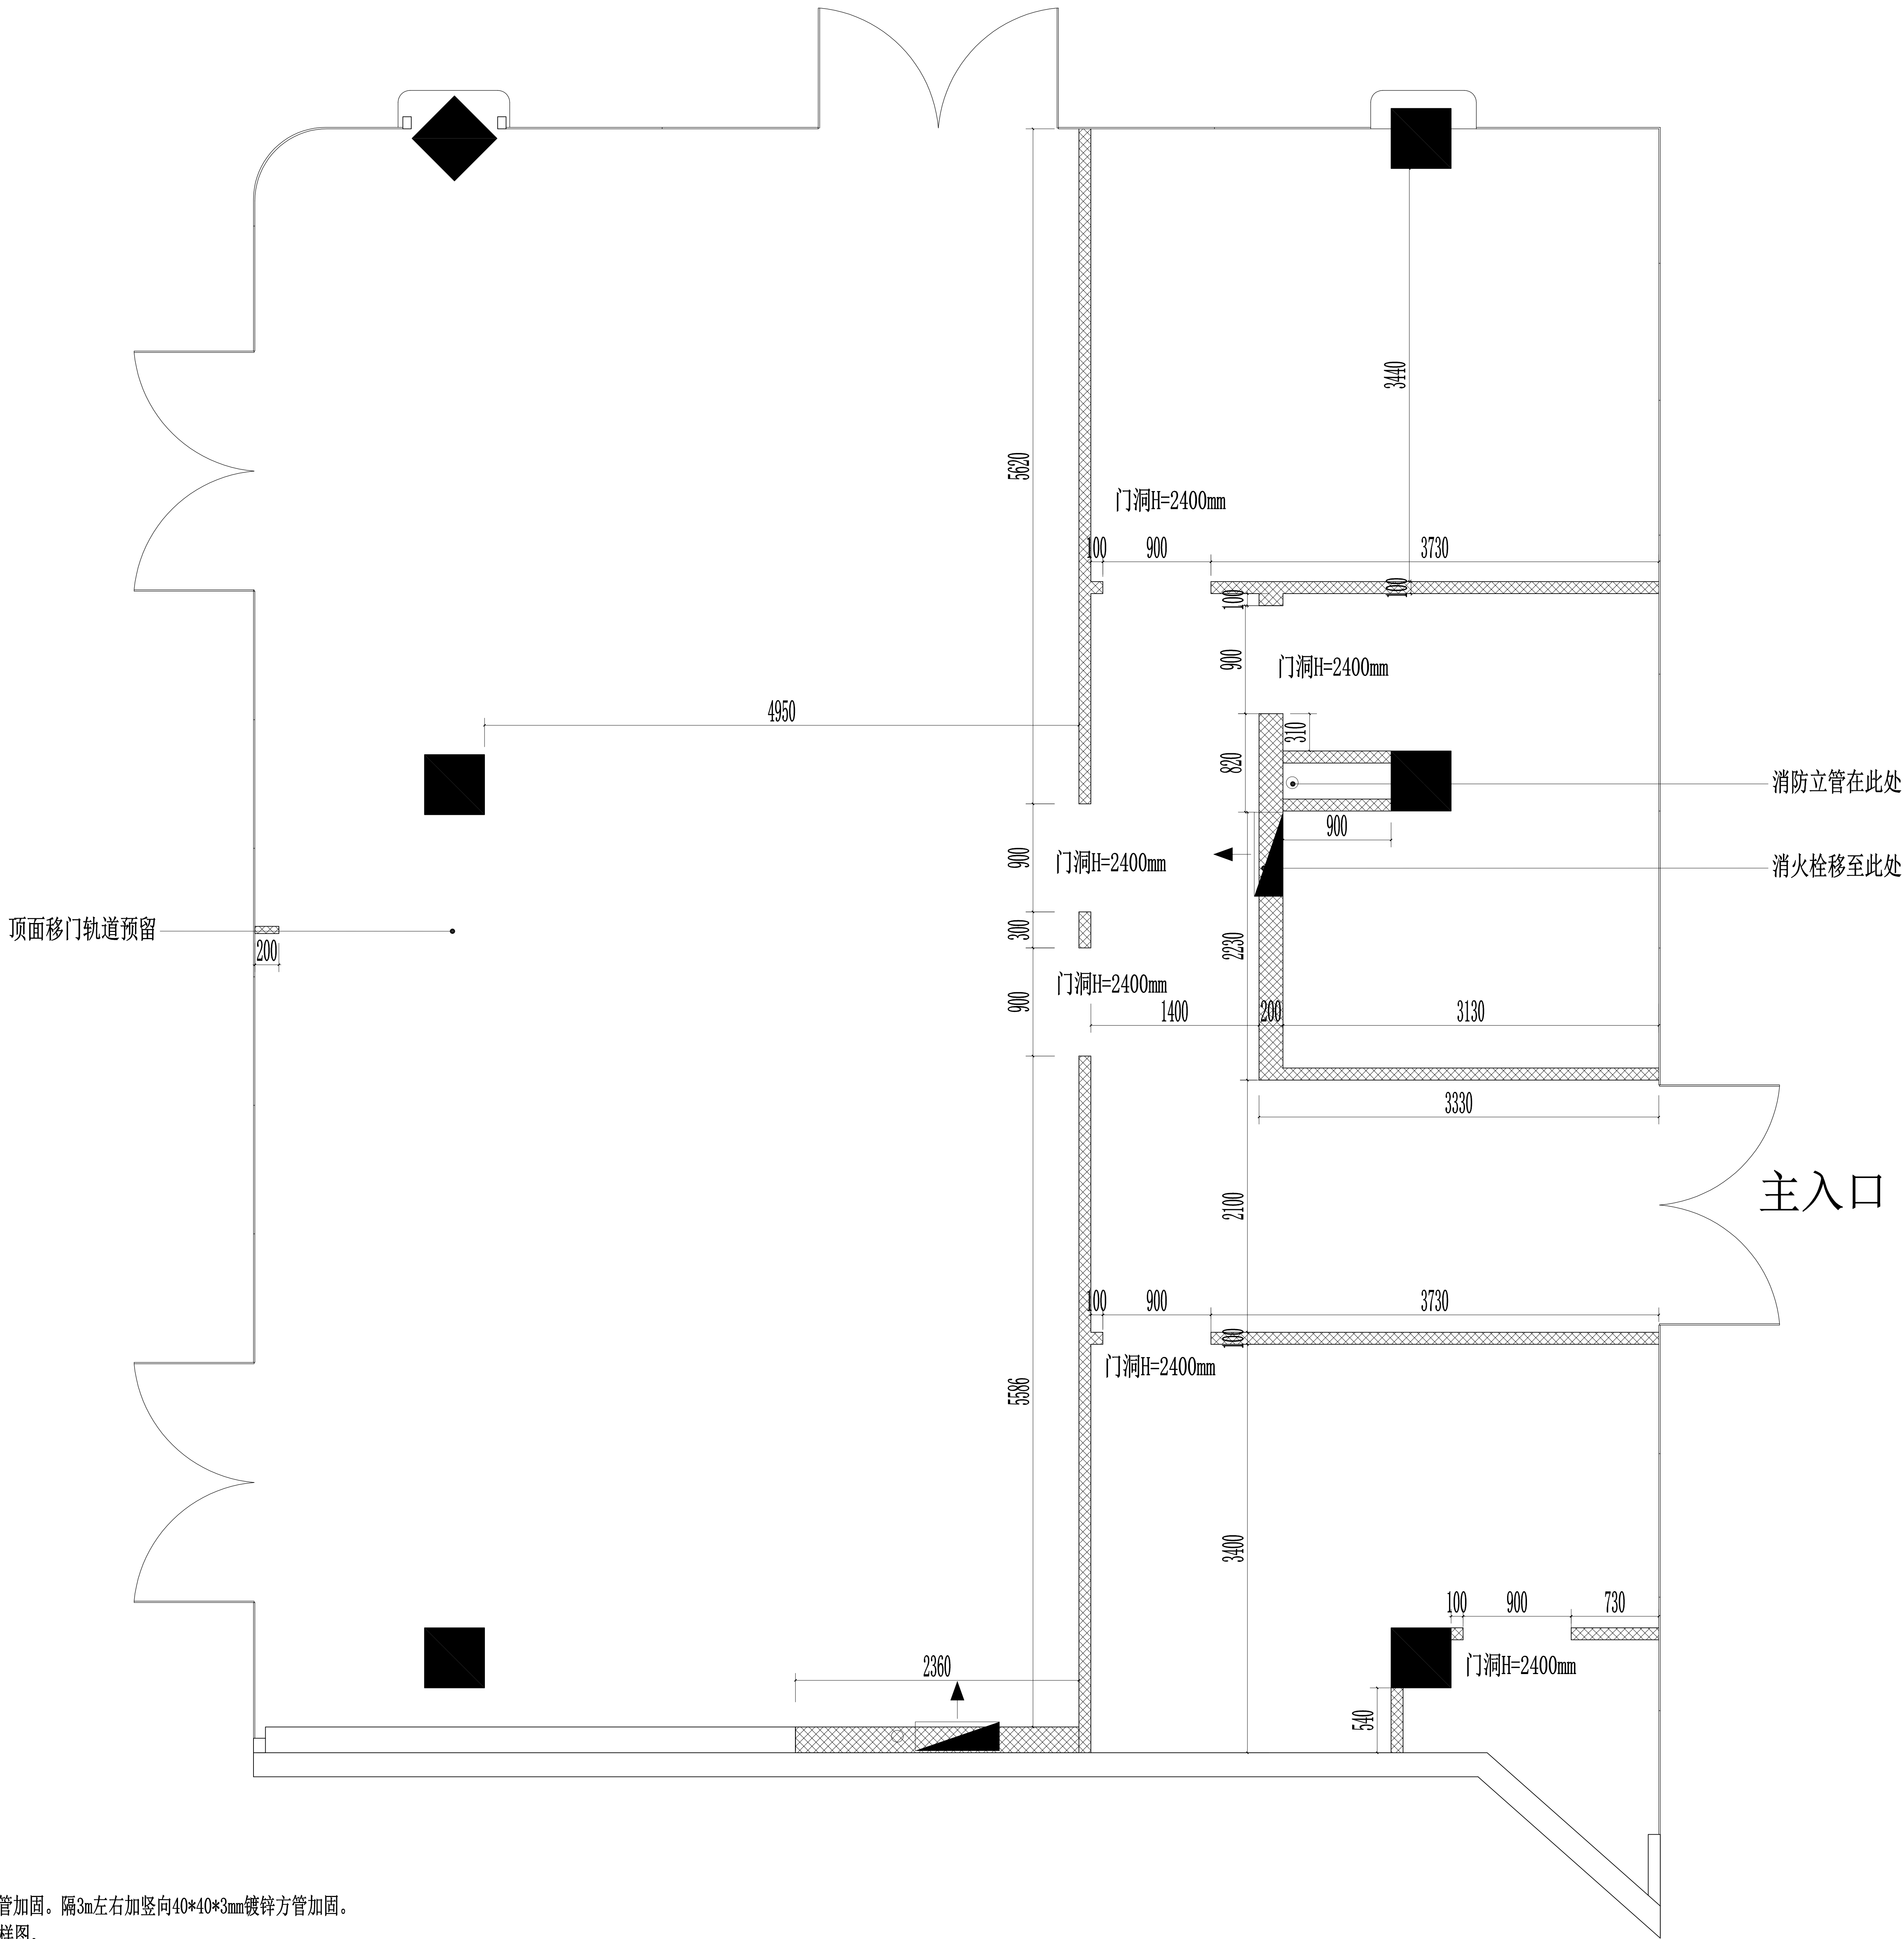

ZI LANG

江苏紫澜门装饰股份有限公司
Jiangsu Zilanmen Decoration Co., Ltd.
http://www.zilang.com

紫浪装饰设计
ZI LANG DESIGN

海门大剧院文化中心商铺装修设计项目

CHINA

HAIMEN

4区（157m²）新建墙体图

DRAWING TITLE

ALL DESIGNS AND SPECIFICATIONS ARE THE PROPERTY OF ZI LANG DESIGN LTD. AND CANNOT BE USED WITHOUT THEIR WRITTEN PERMISSION. THE SAME SHALL BE RETURNED UPON COMPLETION OF THE PROJECT. DO NOT SCALE DRAWINGS. ALL MEASUREMENTS MUST BE CHECKED ON SITE BY THE CONTRACTORS AND ANY DISCREPANCIES BROUGHT TO THE ATTENTION OF THE DESIGNER OR ARCHITECT. THIS DRAWING IS TO BE USED FOR THE PROJECT AND SITE IDENTIFIED AND NOT TO BE USED ON ANY OTHER PROJECT.

REVISION DATE

Scale 比例 Date 日期

1:60@A2 PH


Designed BY 设计 PH

Job NO. 项目编号 APPROVED BY 核准

PH

Sheet NO. 图号 PH

4Q-P-02 页码

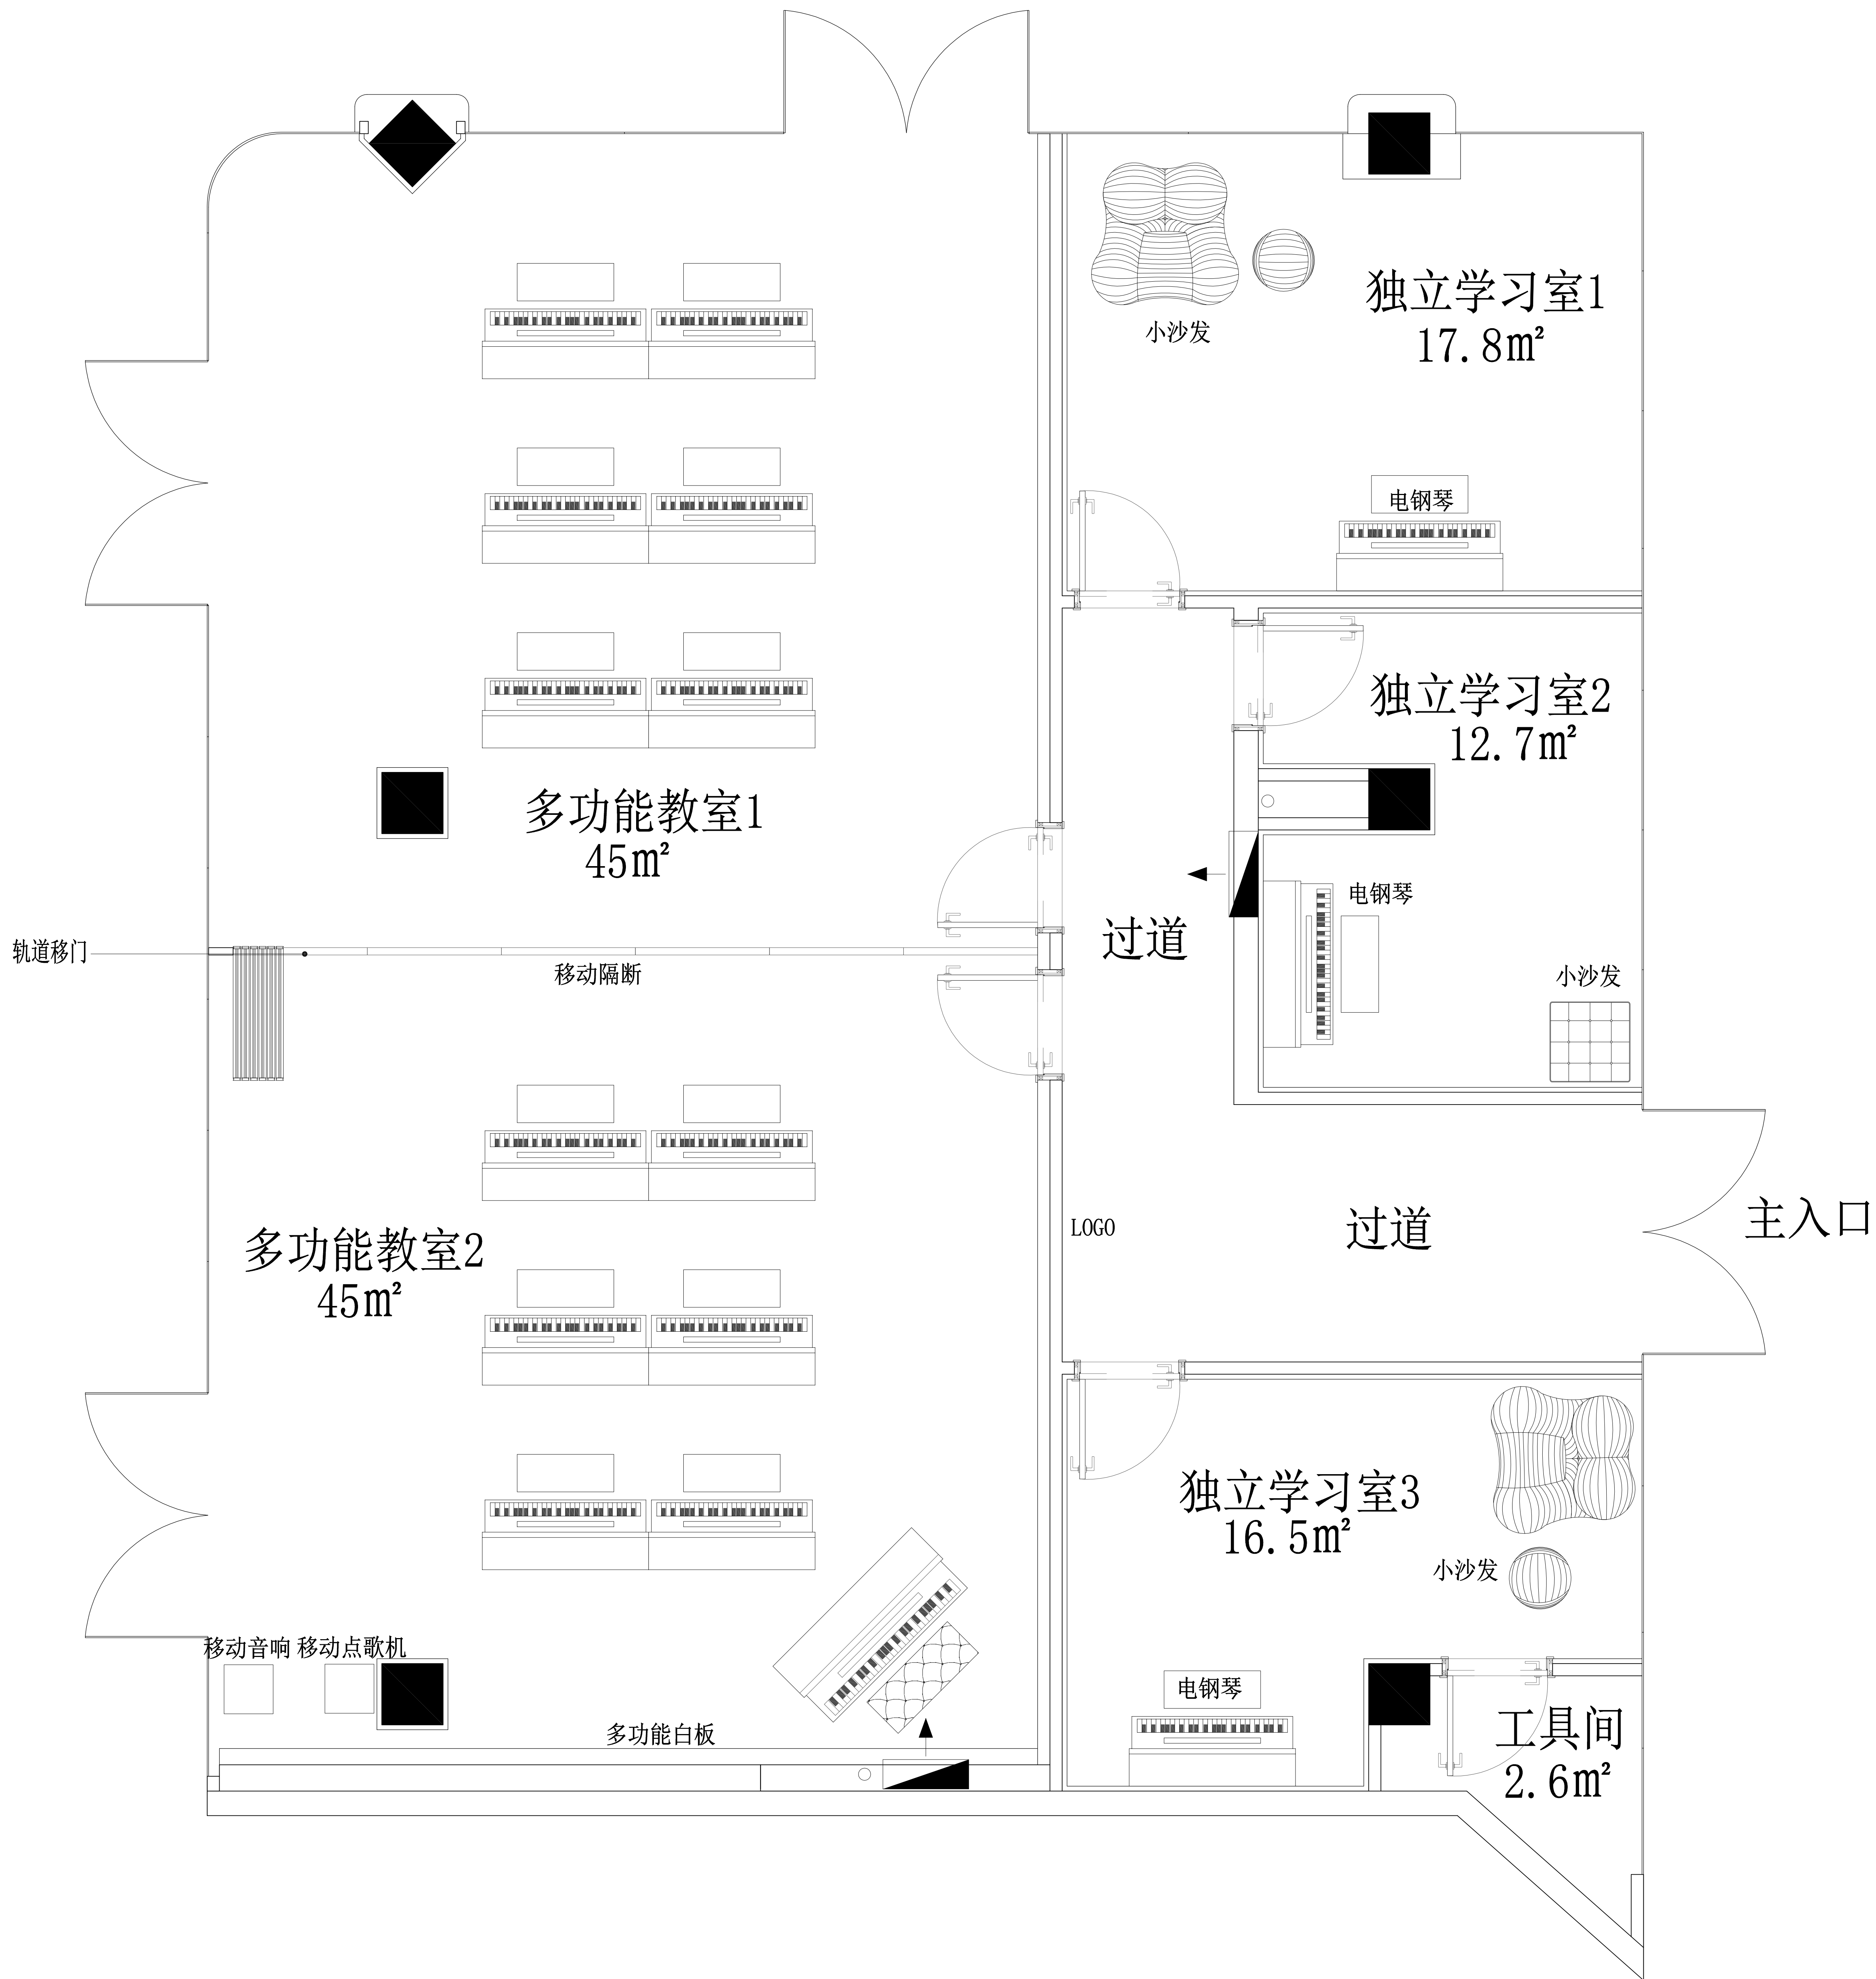

海门大剧院文化中心商铺装修设计项目

CHINA

HAIMEN



ZI LANG

江苏海门市海门大街45号光彩大厦
TEL: 0513-86211885 FAX: 0513-86211887
http://www.zilang.com

紫浪装饰设计
ZI LANG · DESIGNED

DRAWING TITLE

4区（157m²）平面布置图

ALL DESIGNS AND SPECIFICATIONS ARE THE PROPERTY OF ZI LANG DESIGN LTD. AND CANNOT BE USED WITHOUT THEIR WRITTEN PERMISSION. THE SAME SHALL BE RETURNED UPON COMPLETION OF THE PROJECT. DO NOT SCALE DRAWINGS. ALL MEASUREMENTS MUST BE CHECKED ON SITE BY THE CONTRACTORS AND ANY DISCREPANCIES BROUGHT TO THE ATTENTION OF THE DESIGNER OR ARCHITECT. THIS DRAWING IS TO BE USED FOR THE PROJECT AND SITE IDENTIFIED AND NOT TO BE USED ON ANY OTHER PROJECT.

REVISION DATE

Scale 比例 Date 日期

PH 1:60@A2 PH

Designed BY 设计 Drawn BY 绘图

PH PH


Job NO. 项目编号 APPROVED BY 核准

PH PH

Sheet NO. 图号 页码

4Q-P-03

图例	名称	规格/型号
	喷淋头	
	烟感	
	方形出风口	
	方形回风口	600*600
	条形回风口	300*1200
	双头方筒灯	4000K
	LED平板灯	600*600, 4000K
	吸顶定阻音箱	
	400W高清半球	
	应急筒灯	

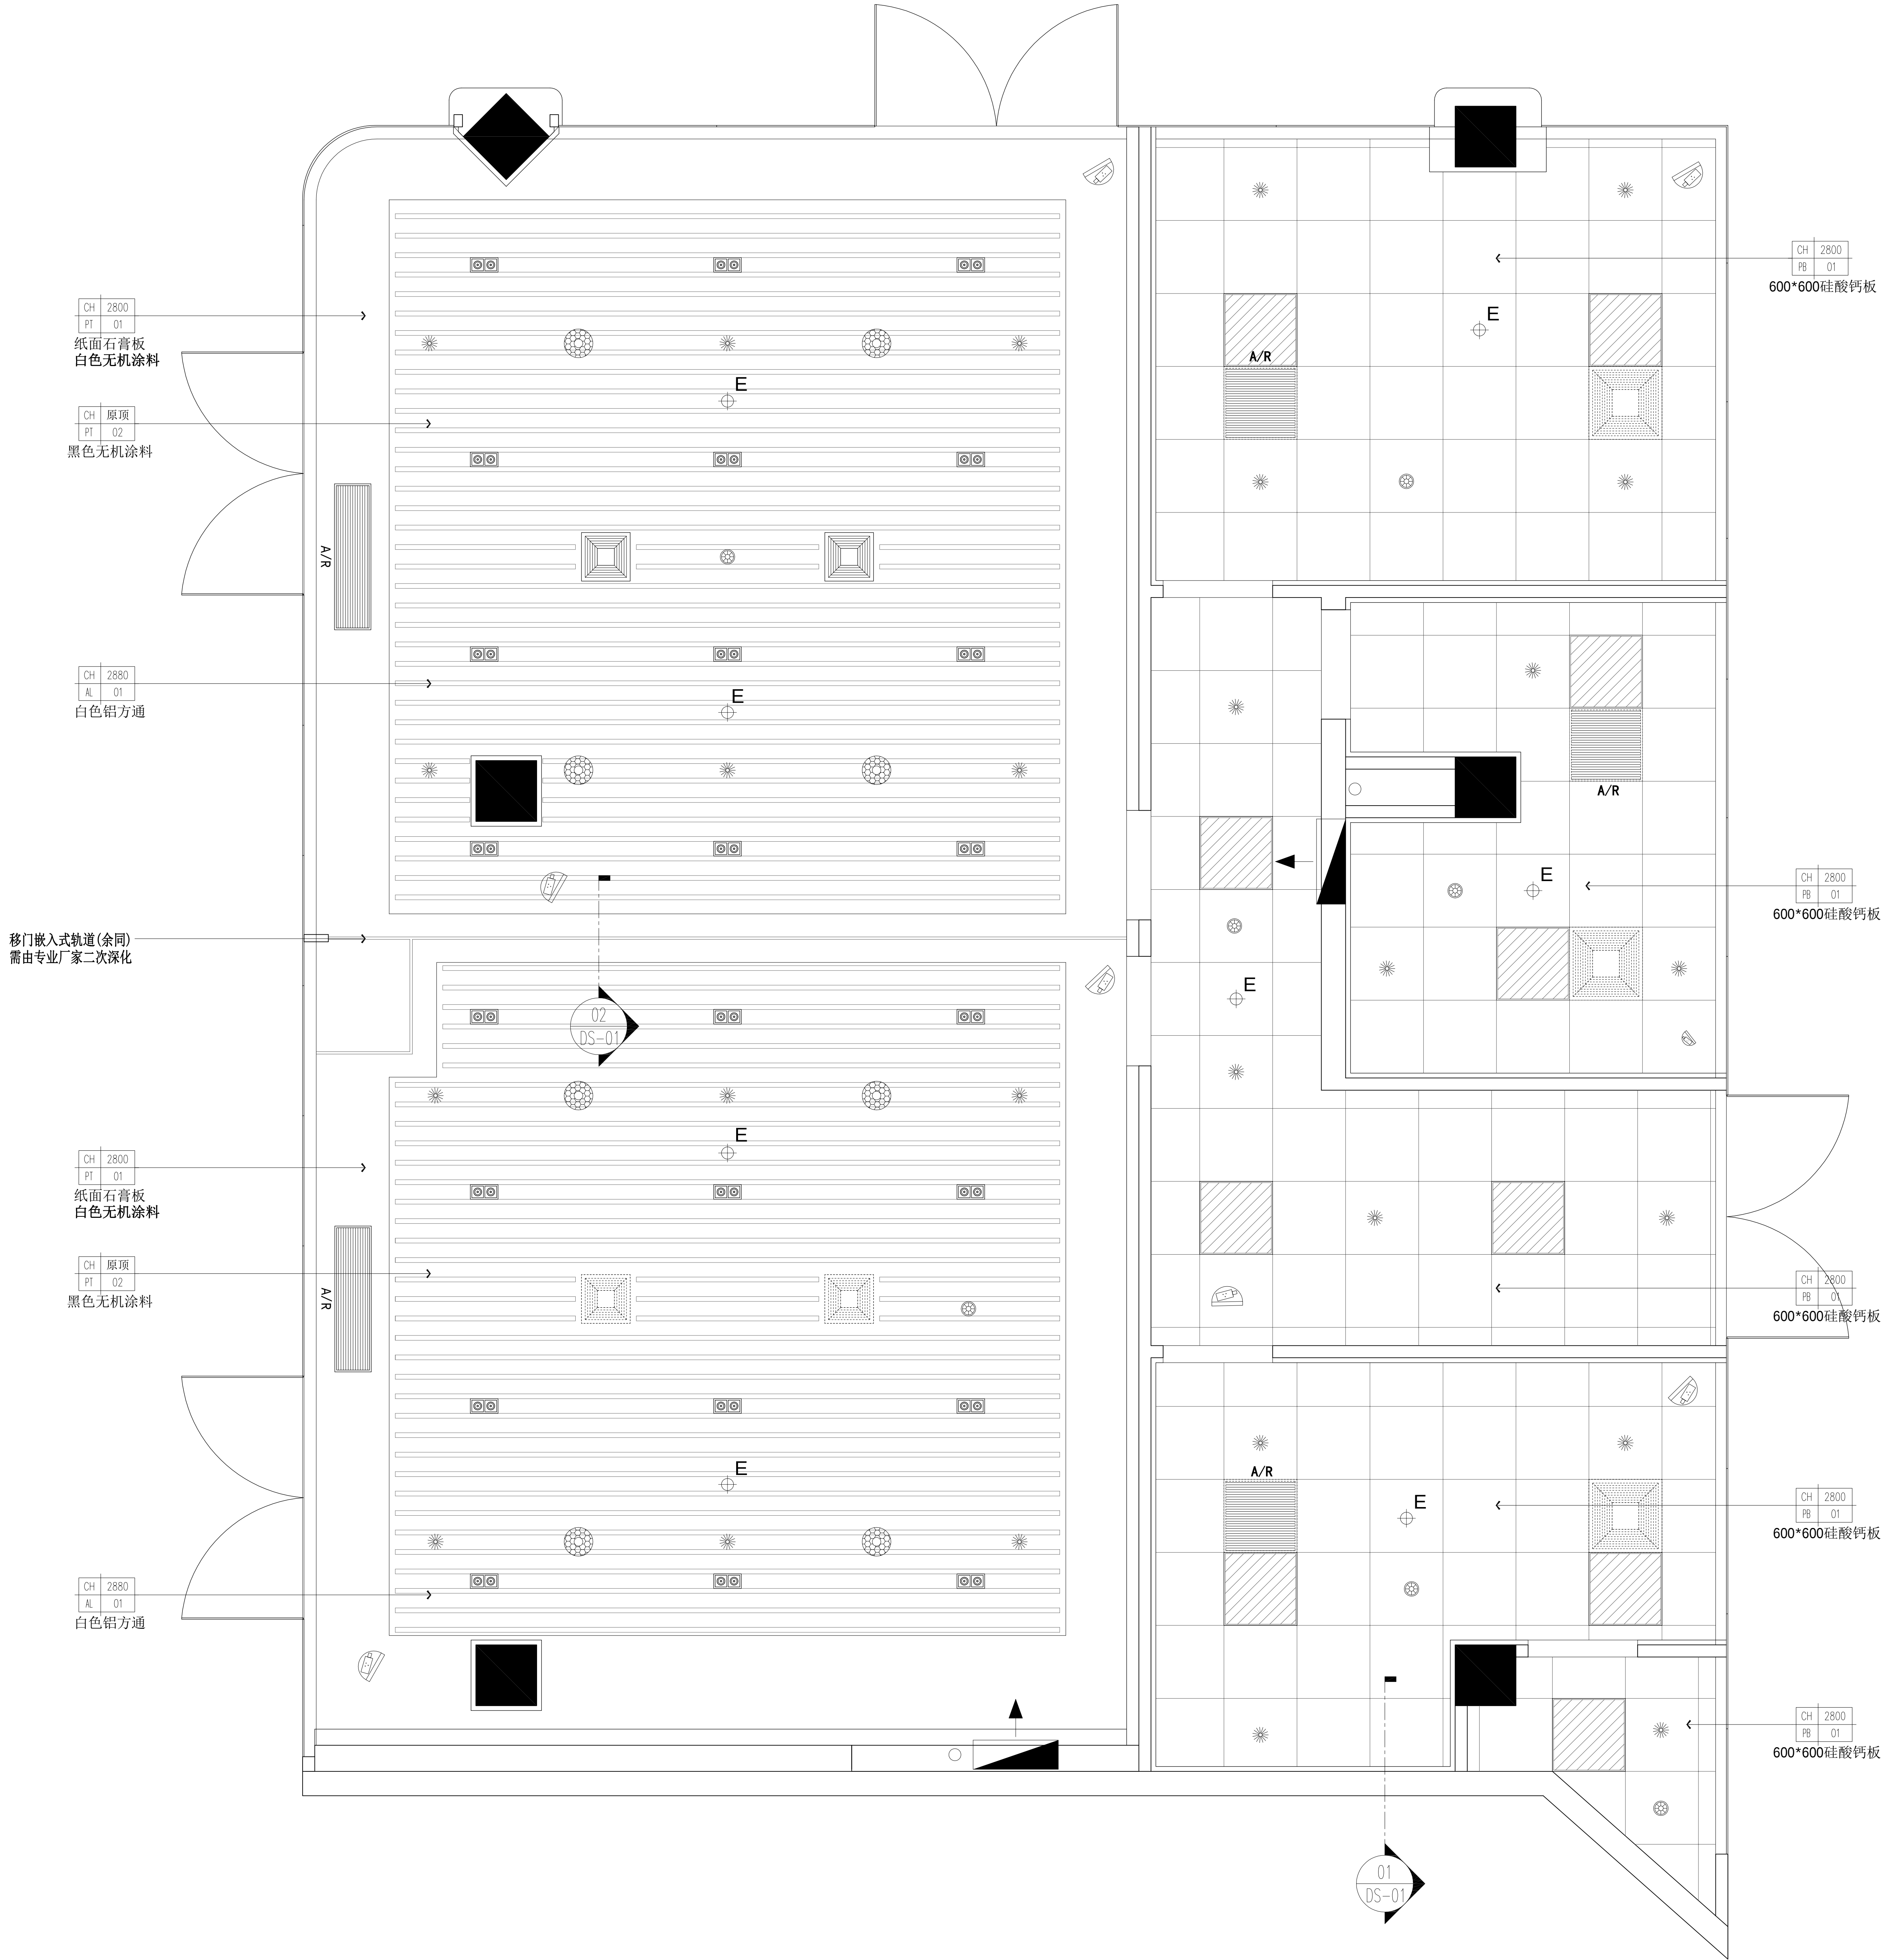

江苏海门市海门路95号光弘大厦
TEL: 0513-82215855 FAX: 0513-82215857
http://www.jzlang.com

紫浪装饰设计
ZI LANG . DESIGNED

海门大剧院文化中心商铺装修设计项目

CHINA

HAIMEN

4区 (157m²) 顶面布置图

ALL DESIGNS AND SPECIFICATIONS ARE THE PROPERTY OF ZI LANG DESIGN LTD. AND CANNOT BE USED WITHOUT THEIR WRITTEN PERMISSION. THE SAME SHALL BE RETURNED UPON COMPLETION OF THE PROJECT. DO NOT SCALE DRAWINGS. ALL MEASUREMENTS MUST BE CHECKED ON SITE BY THE CONTRACTORS AND ANY DISCREPANCIES BROUGHT TO THE ATTENTION OF THE DESIGNER OR ARCHITECT. THIS DRAWING IS TO BE USED FOR THE PROJECT AND SITE IDENTIFIED AND NOT TO BE USED ON ANY OTHER PROJECT.

REVISION DATE


Scale 比例 Date 日期

PH 1:60@A2 PH
Designed BY 设计 Drawn BY 绘图

PH PH
Job NO. 项目编号 APPROVED BY 核准

PH PH
Sheet NO. 图号 页码

4Q-P-04

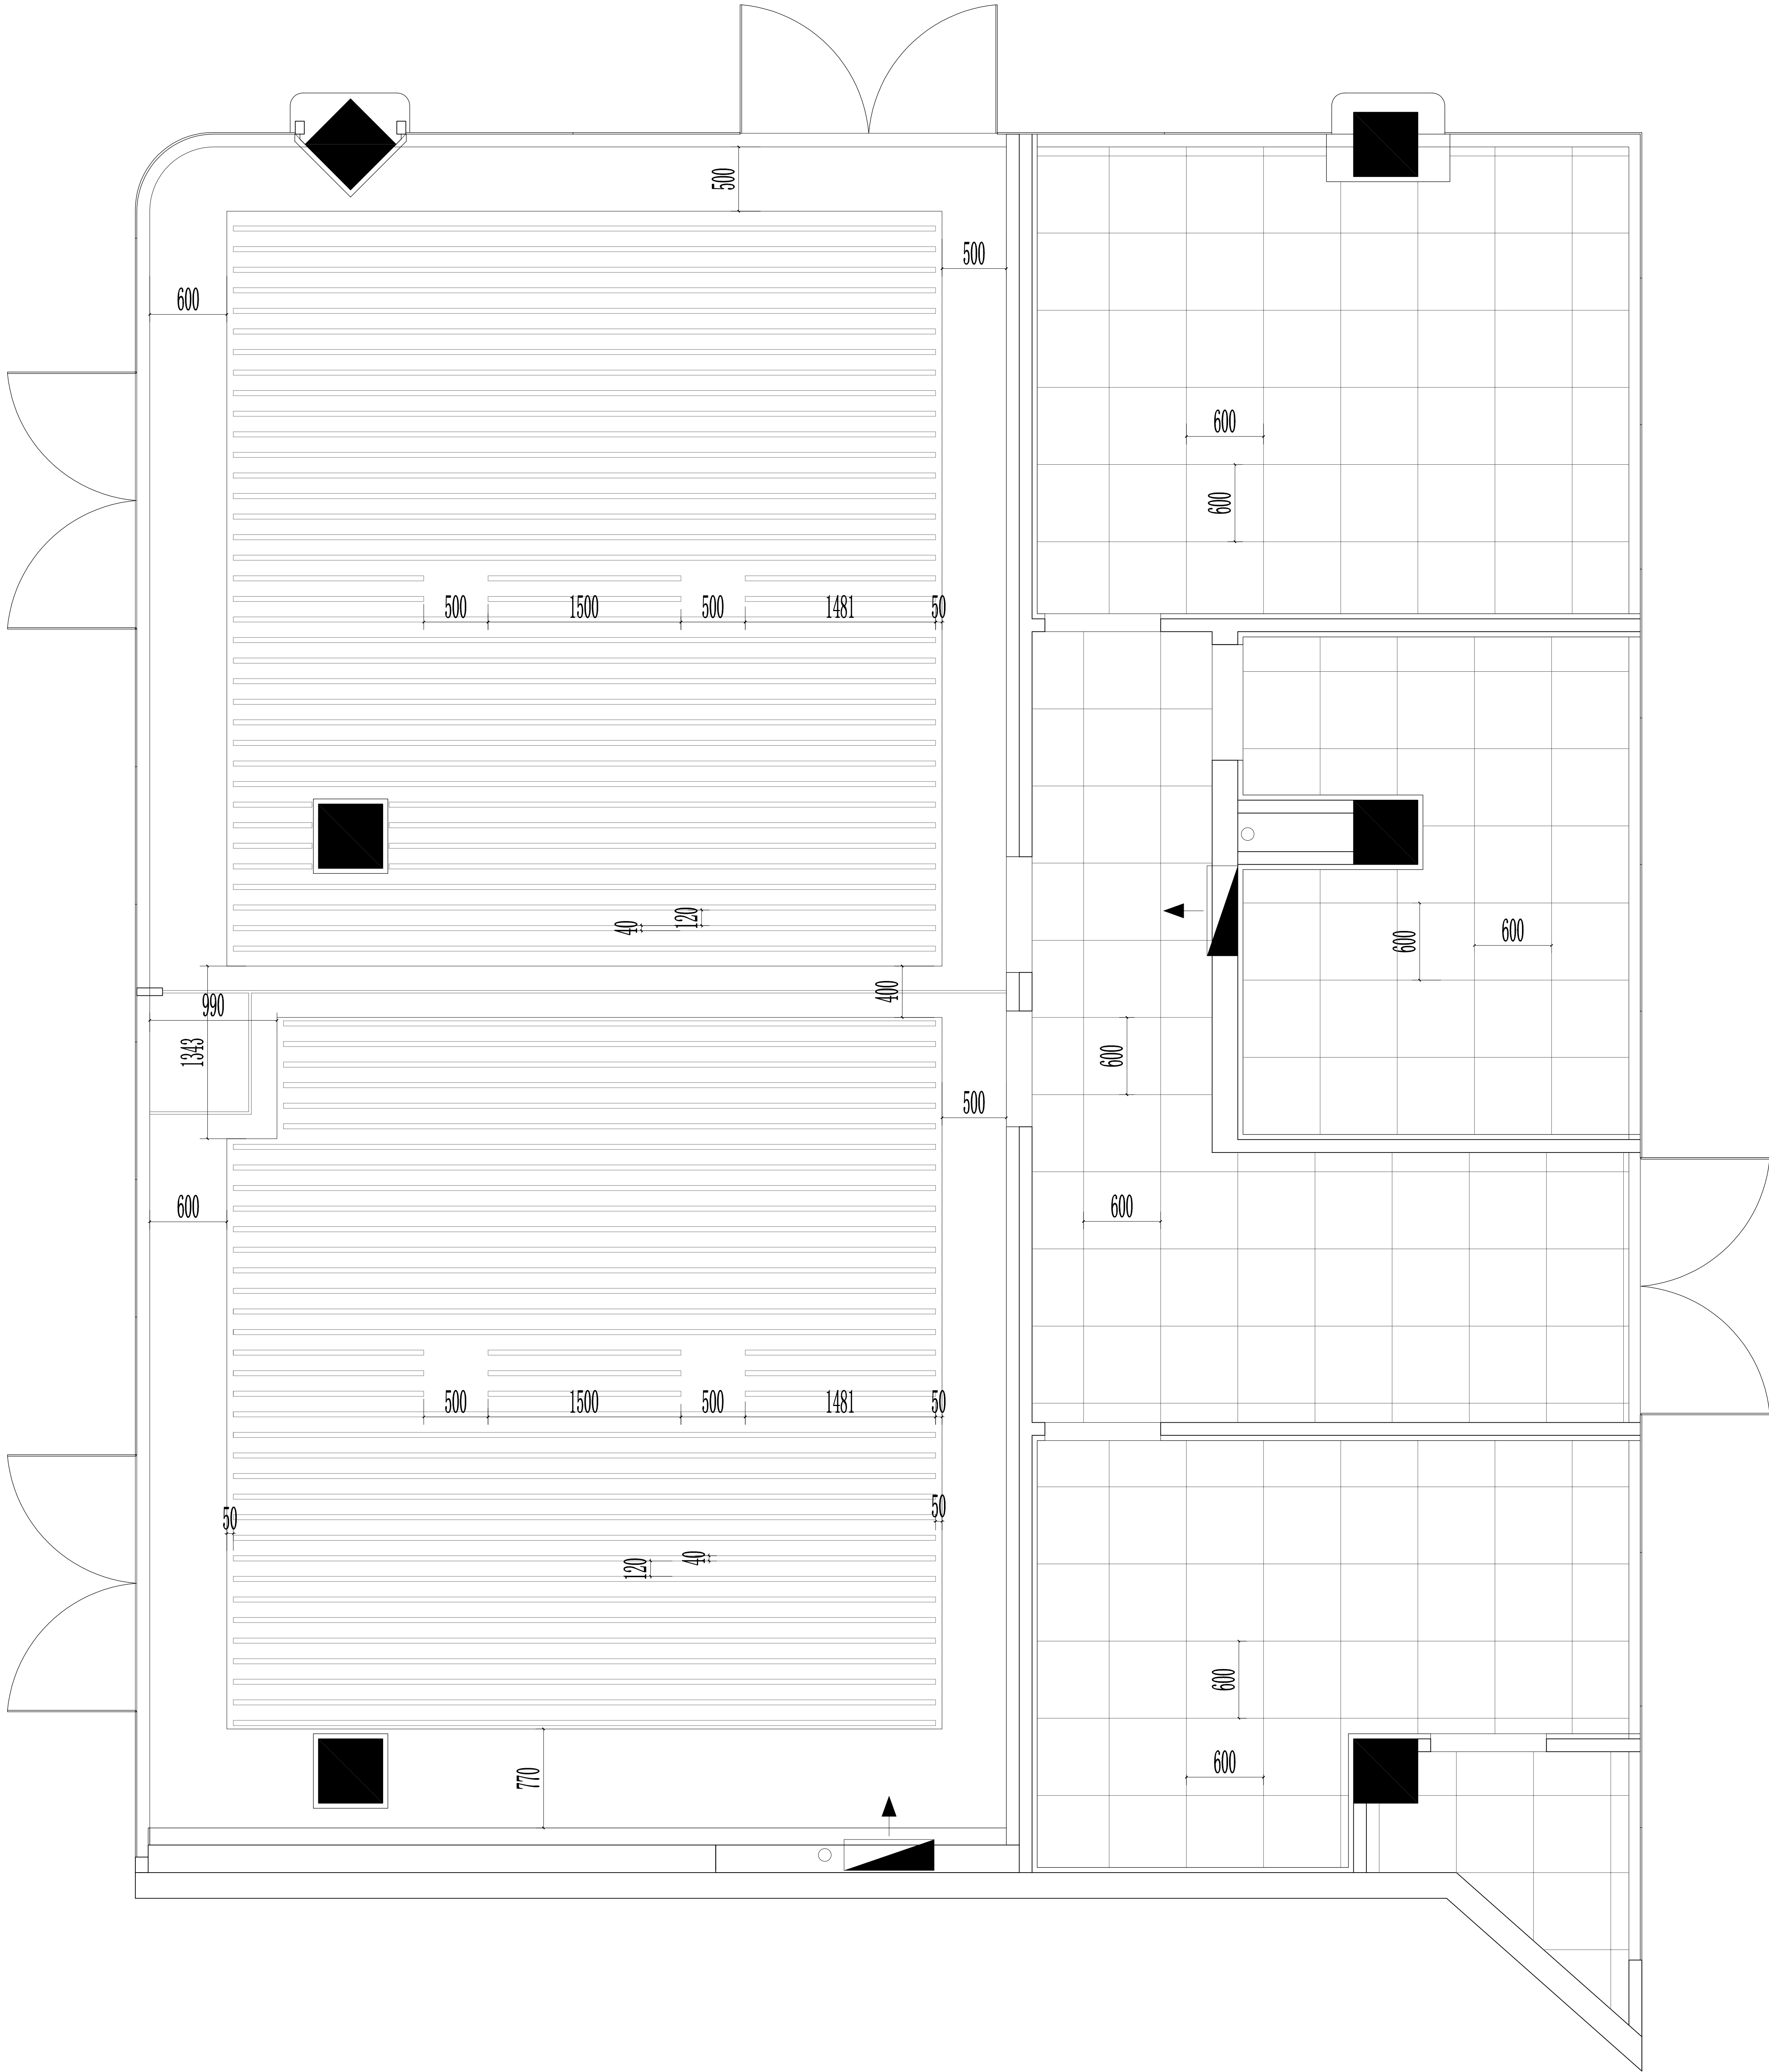

江苏省海门市海门路99号光彩大厦
TEL:0513-82213853 FAX:0513-82213857
http://www.zilang.com

紫浪装饰设计
ZI LANG . DESIGNED

海门大剧院文化中心商铺装修设计项目

HA IMEN CHINA

4区（157m²）顶面造型尺寸图

ALL DESIGNS AND SPECIFICATIONS ARE THE PROPERTY OF ZI LANG DESIGN LTD. AND CANNOT BE USED WITHOUT THEIR WRITTEN PERMISSION. THE SAME SHALL BE RETURNED UPON COMPLETION OF THE PROJECT. DO NOT SCALE DRAWINGS. ALL MEASUREMENTS MUST BE CHECKED ON SITE BY THE CONTRACTORS AND ANY DISCREPANCIES BROUGHT TO THE ATTENTION OF THE DESIGNER OR ARCHITECT. THIS DRAWING IS TO BE USED FOR THE PROJECT AND SITE IDENTIFIED AND NOT TO BE USED ON ANY OTHER PROJECT.

REVISION DATE

Scale 比例 Date 日期

PH 1:60@A2 PH

Designed BY 设计 Drawn BY 绘图


PH PH

Job NO. 项目编号 APPROVED BY 核准

PH PH

Sheet NO. 图号 页码

4Q-P-05

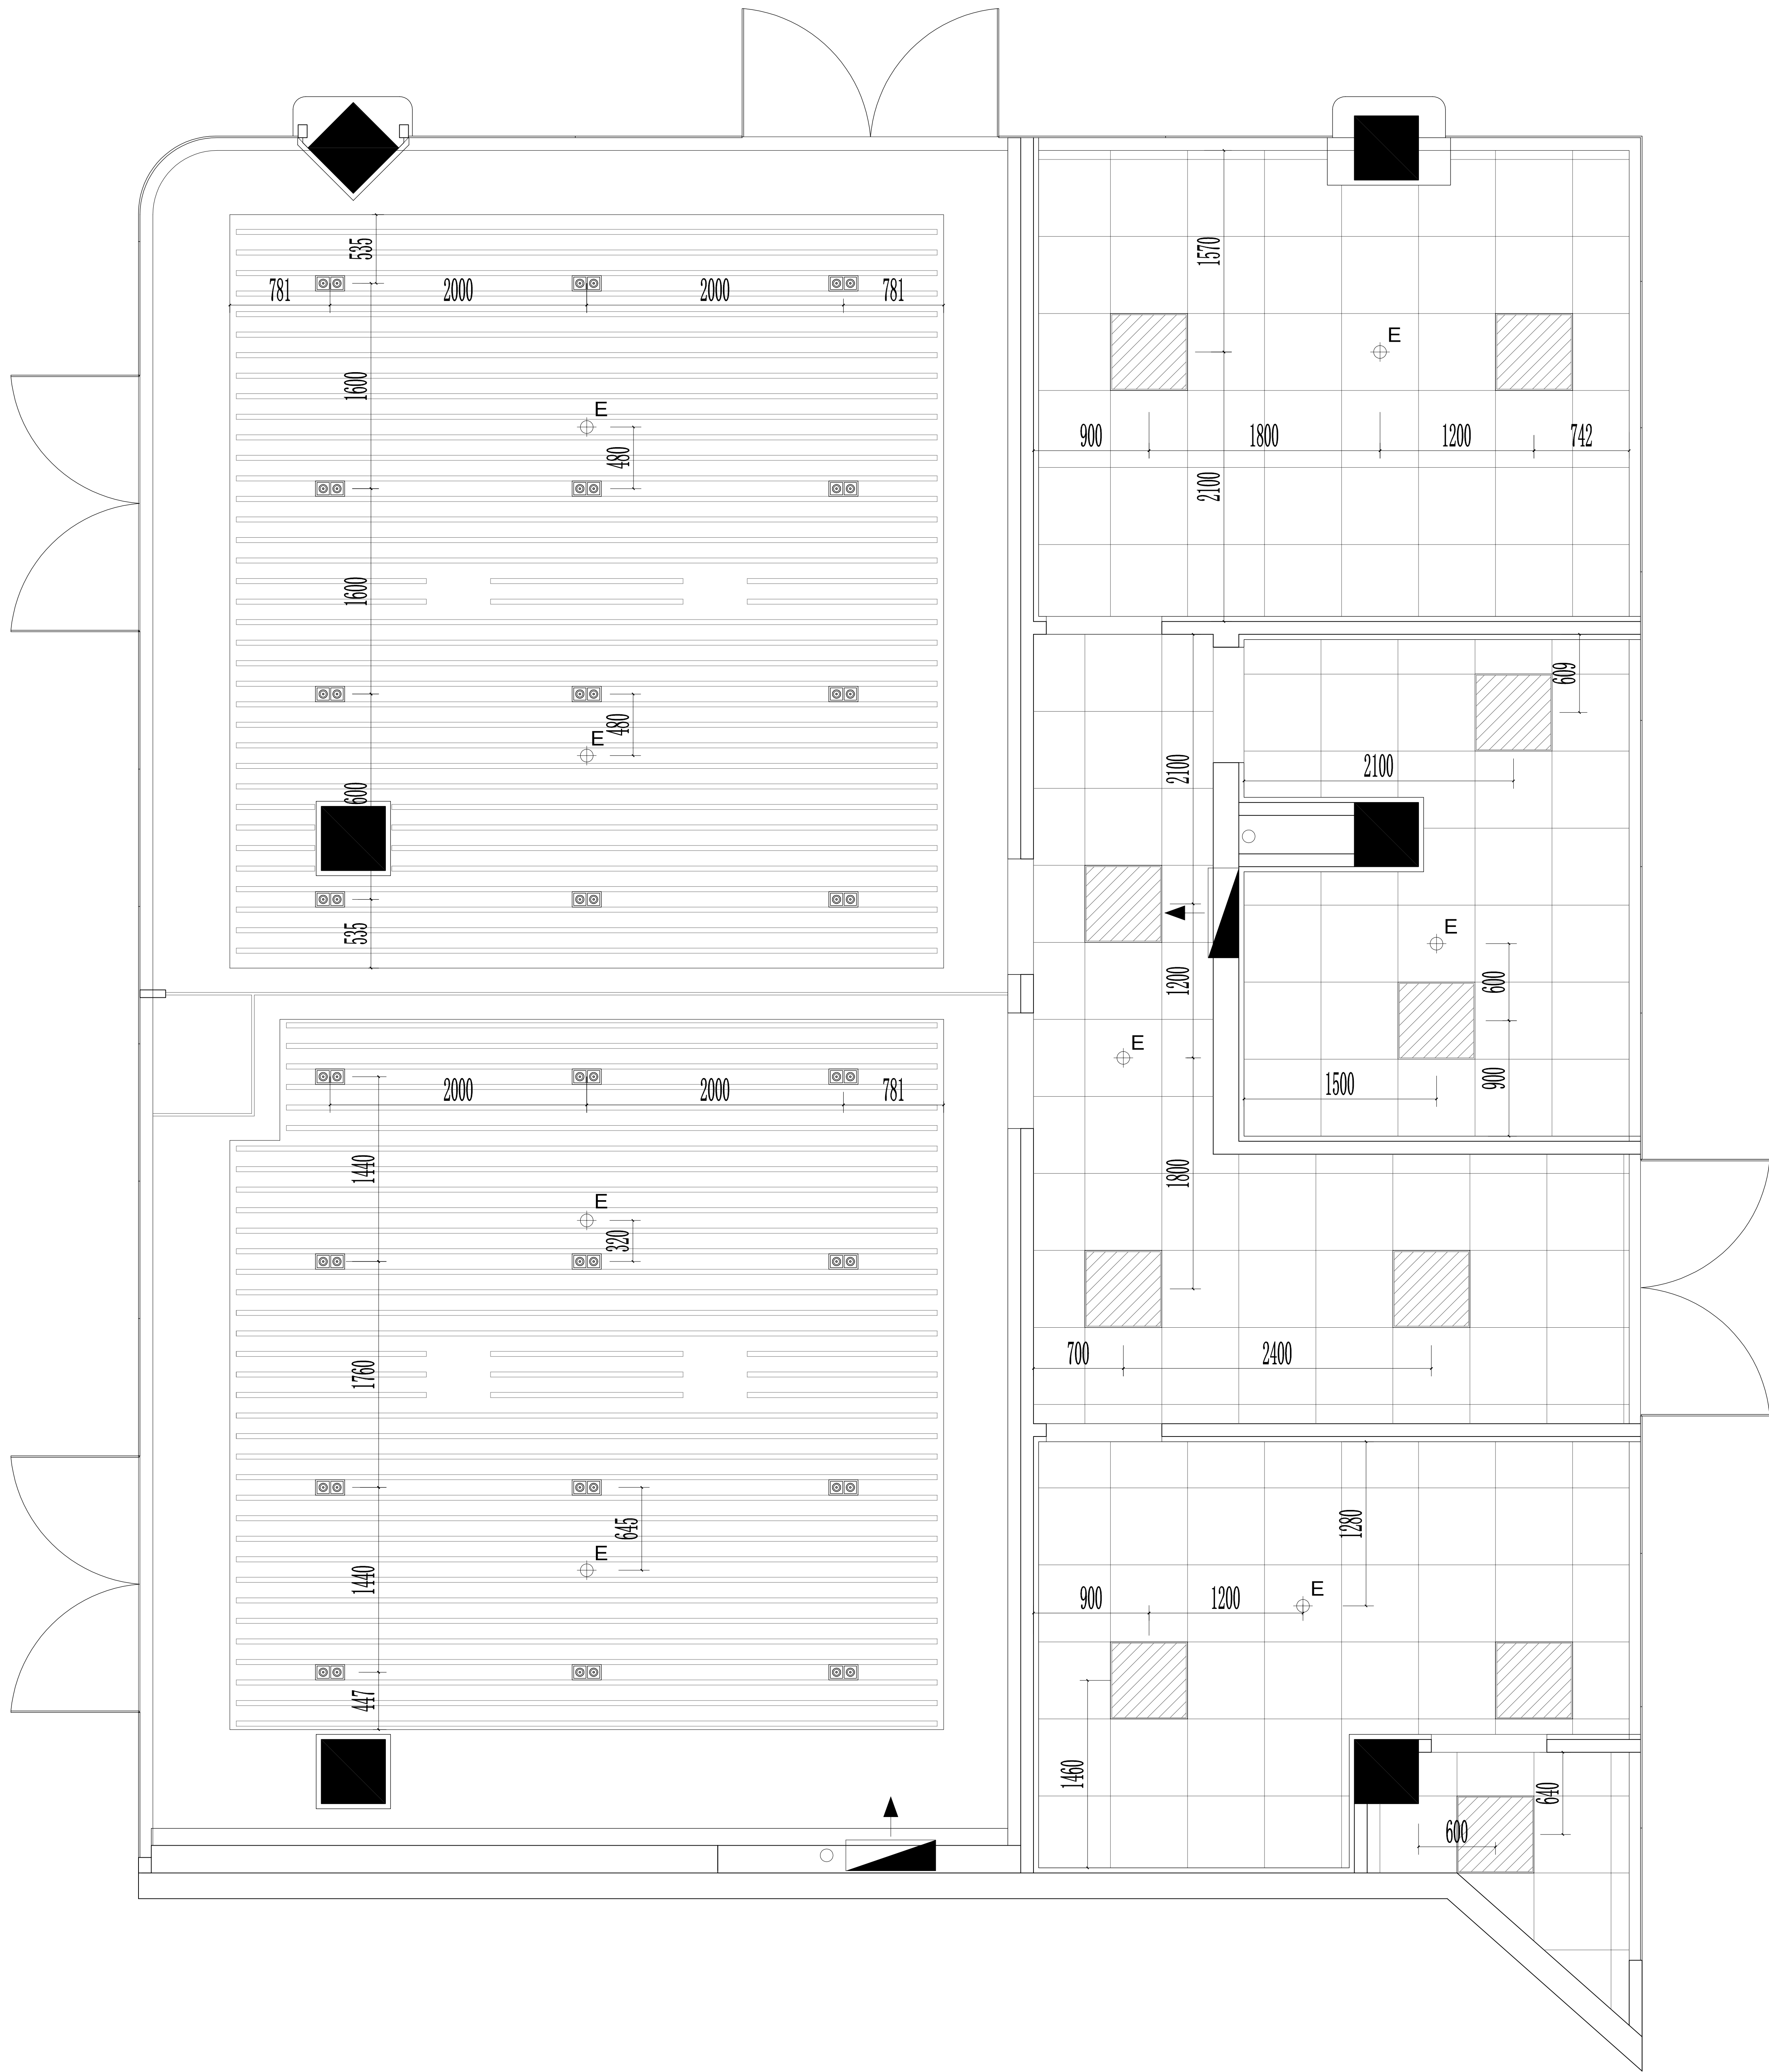

4区 (157m²) 顶面灯具定位图

ALL DESIGNS AND SPECIFICATIONS ARE THE PROPERTY OF ZI LANG DESIGN LTD. AND CANNOT BE USED WITHOUT THEIR WRITTEN PERMISSION. THE SAME SHALL BE RETURNED UPON COMPLETION OF THE PROJECT. DO NOT SCALE DRAWINGS. ALL MEASUREMENTS MUST BE CHECKED ON SITE BY THE CONTRACTORS AND ANY DISCREPANCIES BROUGHT TO THE ATTENTION OF THE DESIGNER OR ARCHITECT. THIS DRAWING IS TO BE USED FOR THE PROJECT AND SITE IDENTIFIED AND NOT TO BE USED ON ANY OTHER PROJECT.

REVISION DATE

Scale 比例 Date 日期

PH 1:60@A2 PH

Designed BY 设计 Drawn BY 绘图

PH PH

Job NO. 项目编号 APPROVED BY 核准

PH PH


Sheet NO. 图号 页码

4Q-P-06

海门大剧院文化中心商铺装修设计项目

HA IMEN

CHINA

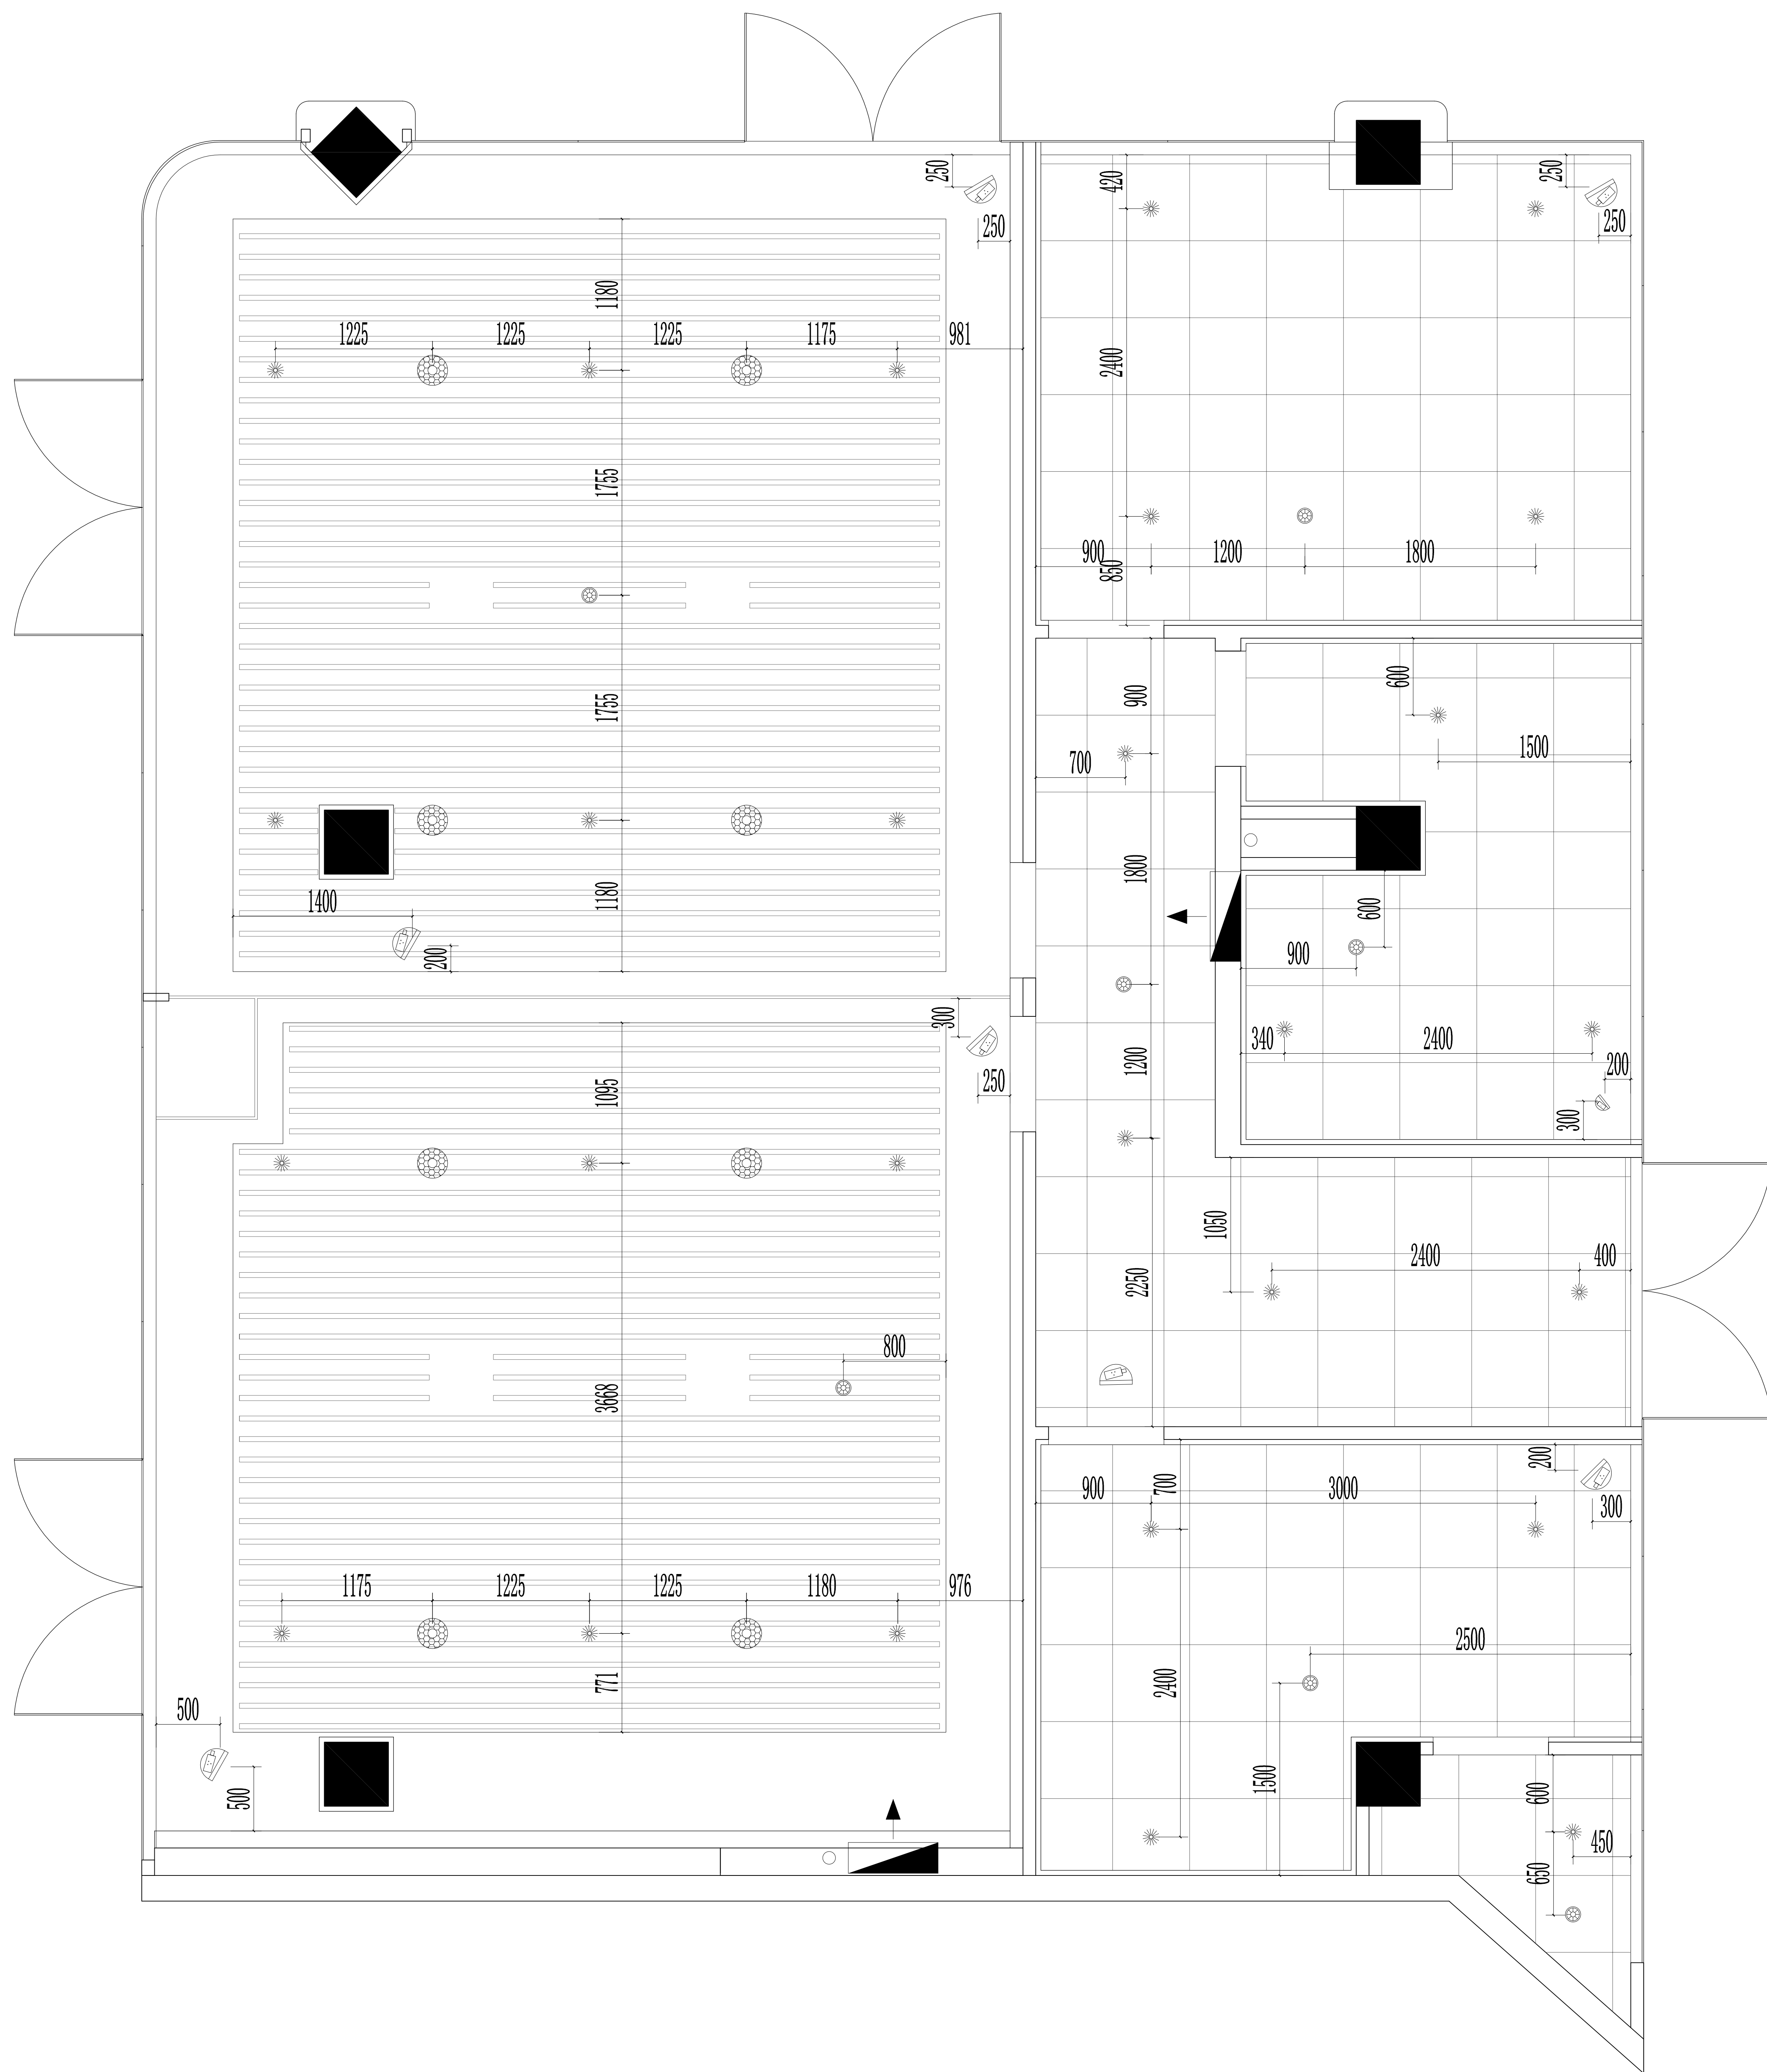

ZILANG

江苏省海门市南海路965号光华大厦
TEL:0513-82315855 FAX:0513-82219367
<http://www.jszszsh.com>

TEL:0513-82315855 FAX:0513-82322222
http://www.jszisz.com

海门大剧院文化中心商铺装修设计项目

HA IMEN

CHINA

4区 (157m²) 消防监控点位尺寸图

DRAWING TITLE

ALL DESIGNS AND SPECIFICATIONS ARE THE PROPERTY OF
ZI LANG DESIGN LTD. AND CANNOT BE USED WITHOUT
THEIR WRITTEN PERMISSION. THE SAME SHALL BE RETURNED
UPON COMPLETION OF THE PROJECT. DO NOT SCALE DRAWINGS.
ALL MEASUREMENTS MUST BE CHECKED ON SITE BY
THE CONTRACTORS AND ANY DISCREPANCIES BROUGHT
TO THE ATTENTION OF THE DESIGNER OR ARCHITECT.
THIS DRAWING IS TO BE USED FOR THE PROJECT AND SITE
IDENTIFIED AND NOT TO BE USED ON ANY OTHER PROJECT.

REVISION	DATE
----------	------

Scale	比例	Date	日期
-------	----	------	----


PH 1:60@A2 PH

Designed BY 设计 Drawn BY 绘图

PH	PH
Job NO.	项目编号 APPROVED BY 核准

PH	PH
Sheet NO. 图号	页码

4Q-P-07

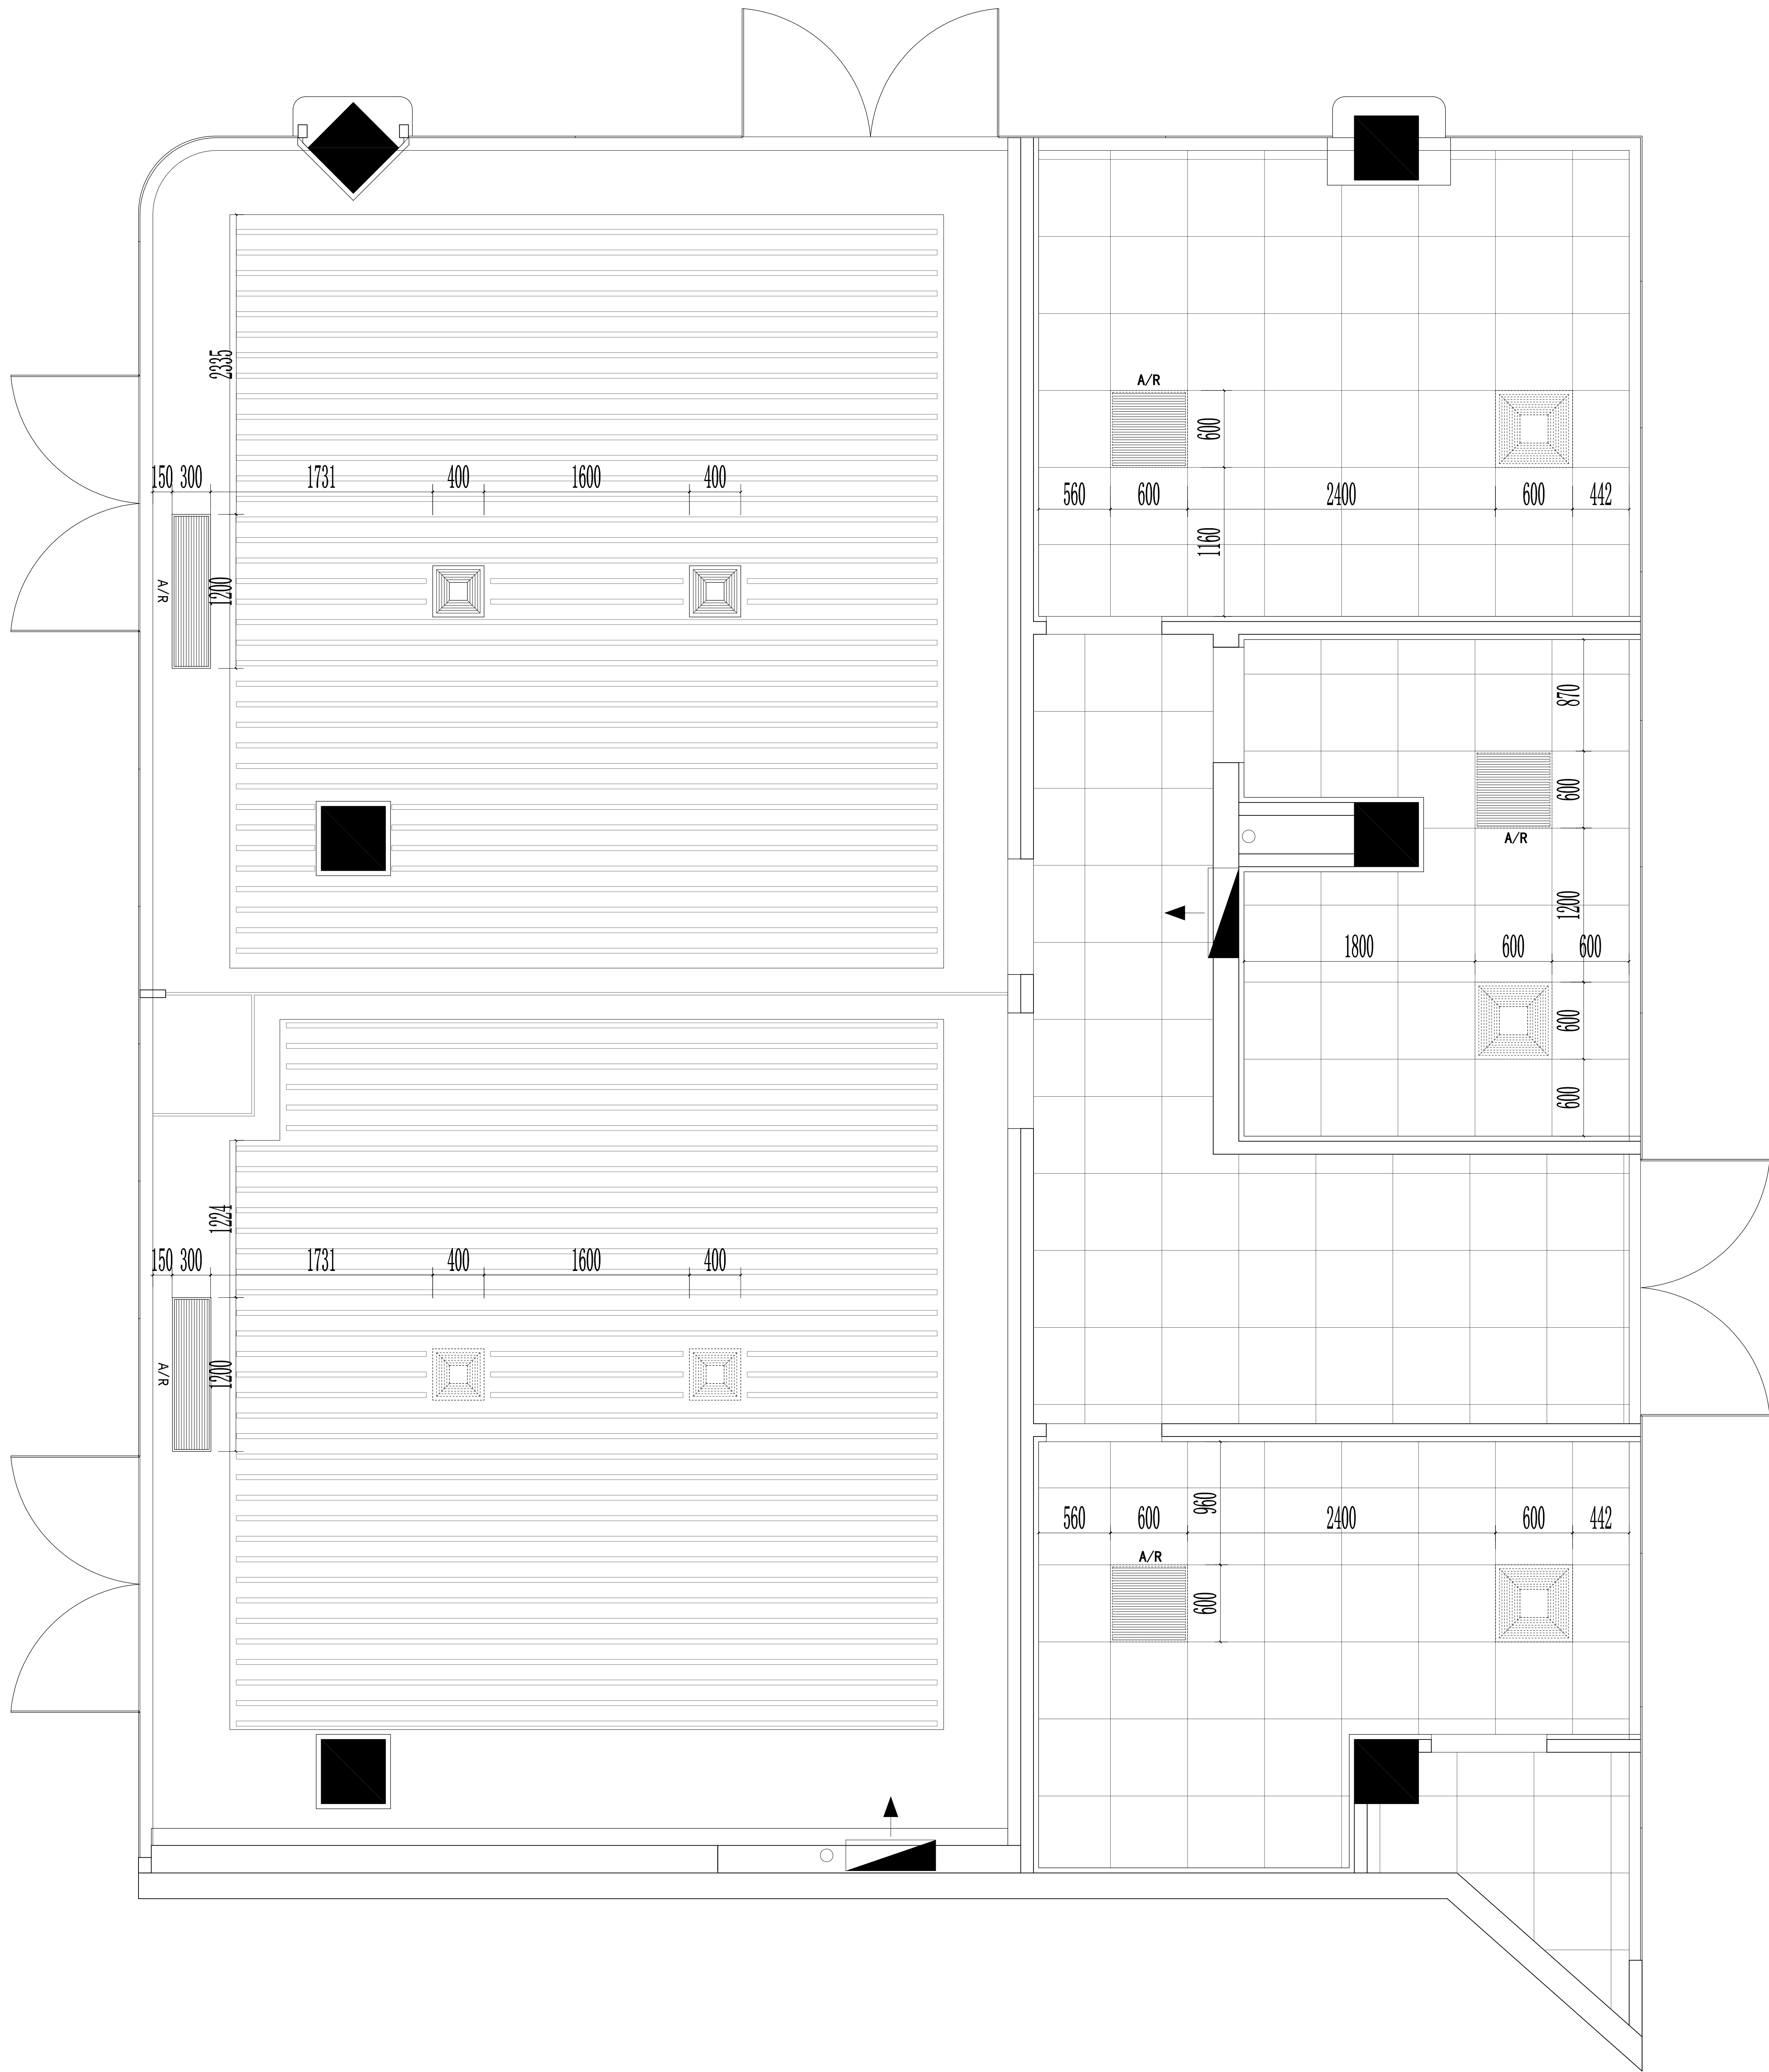

江苏海门市海门路98号光彩大厦
TEL:0513-82213855 FAX:0513-82213857
http://www.zilang.com

紫浪装饰设计
ZI LANG . DESIGNED

海门大剧院文化中心商铺装修设计项目

HAIMEN CHINA

4区（157m²）空调定位图

ALL DESIGNS AND SPECIFICATIONS ARE THE PROPERTY OF ZI LANG DESIGN LTD. AND CANNOT BE USED WITHOUT THEIR WRITTEN PERMISSION. THE SAME SHALL BE RETURNED UPON COMPLETION OF THE PROJECT. DO NOT SCALE DRAWINGS. ALL MEASUREMENTS MUST BE CHECKED ON SITE BY THE CONTRACTORS AND ANY DISCREPANCIES BROUGHT TO THE ATTENTION OF THE DESIGNER OR ARCHITECT. THIS DRAWING IS TO BE USED FOR THE PROJECT AND SITE IDENTIFIED AND NOT TO BE USED ON ANY OTHER PROJECT.

REVISION DATE

Scale 比例 Date 日期

PH 1:60@A2 PH
Designed BY 设计 Drawn BY 绘图

PH PH
Job NO. 项目编号 APPROVED BY 核准

PH PH
Sheet NO. 图号 页码

4Q-P-08


HA I MEN	CH I NA
----------	---------






ALL DESIGNS AND SPECIFICATIONS ARE THE PROPERTY OF ZI LANG DESIGN LTD. AND CANNOT BE USED WITHOUT THEIR WRITTEN PERMISSION. THE SAME SHALL BE RETURNED UPON COMPLETION OF THE PROJECT. DO NOT SCALE DRAWINGS. ALL MEASUREMENTS MUST BE CHECKED ON SITE BY THE CONTRACTORS AND ANY DISCREPANCIES BROUGHT TO THE ATTENTION OF THE DESIGNER OR ARCHITECT. THIS DRAWING IS TO BE USED FOR THE PROJECT AND SITE IDENTIFIED AND NOT TO BE USED ON ANY OTHER PROJECT.


PH PH
Job NO. 项目编号 APPROVED BY 核准

PH	PH
Sheet NO. 图号	页码
4Q-P-09	

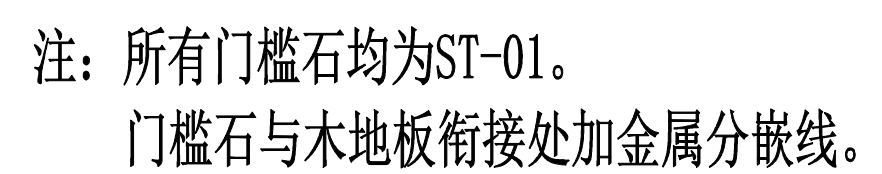

   施工说明:		
	暗装单极开关	下口离地完成面1300mm
	暗装双极开关	下口离地完成面1300mm
	暗装三极开关	下口离地完成面1300mm
	空调开关面板	下口离地完成面1300mm

注:如无特殊说明,开关安装位置离墙边200mm。空调开关紧挨灯具开关柱子上的开关装在中心。 详见电气施工图

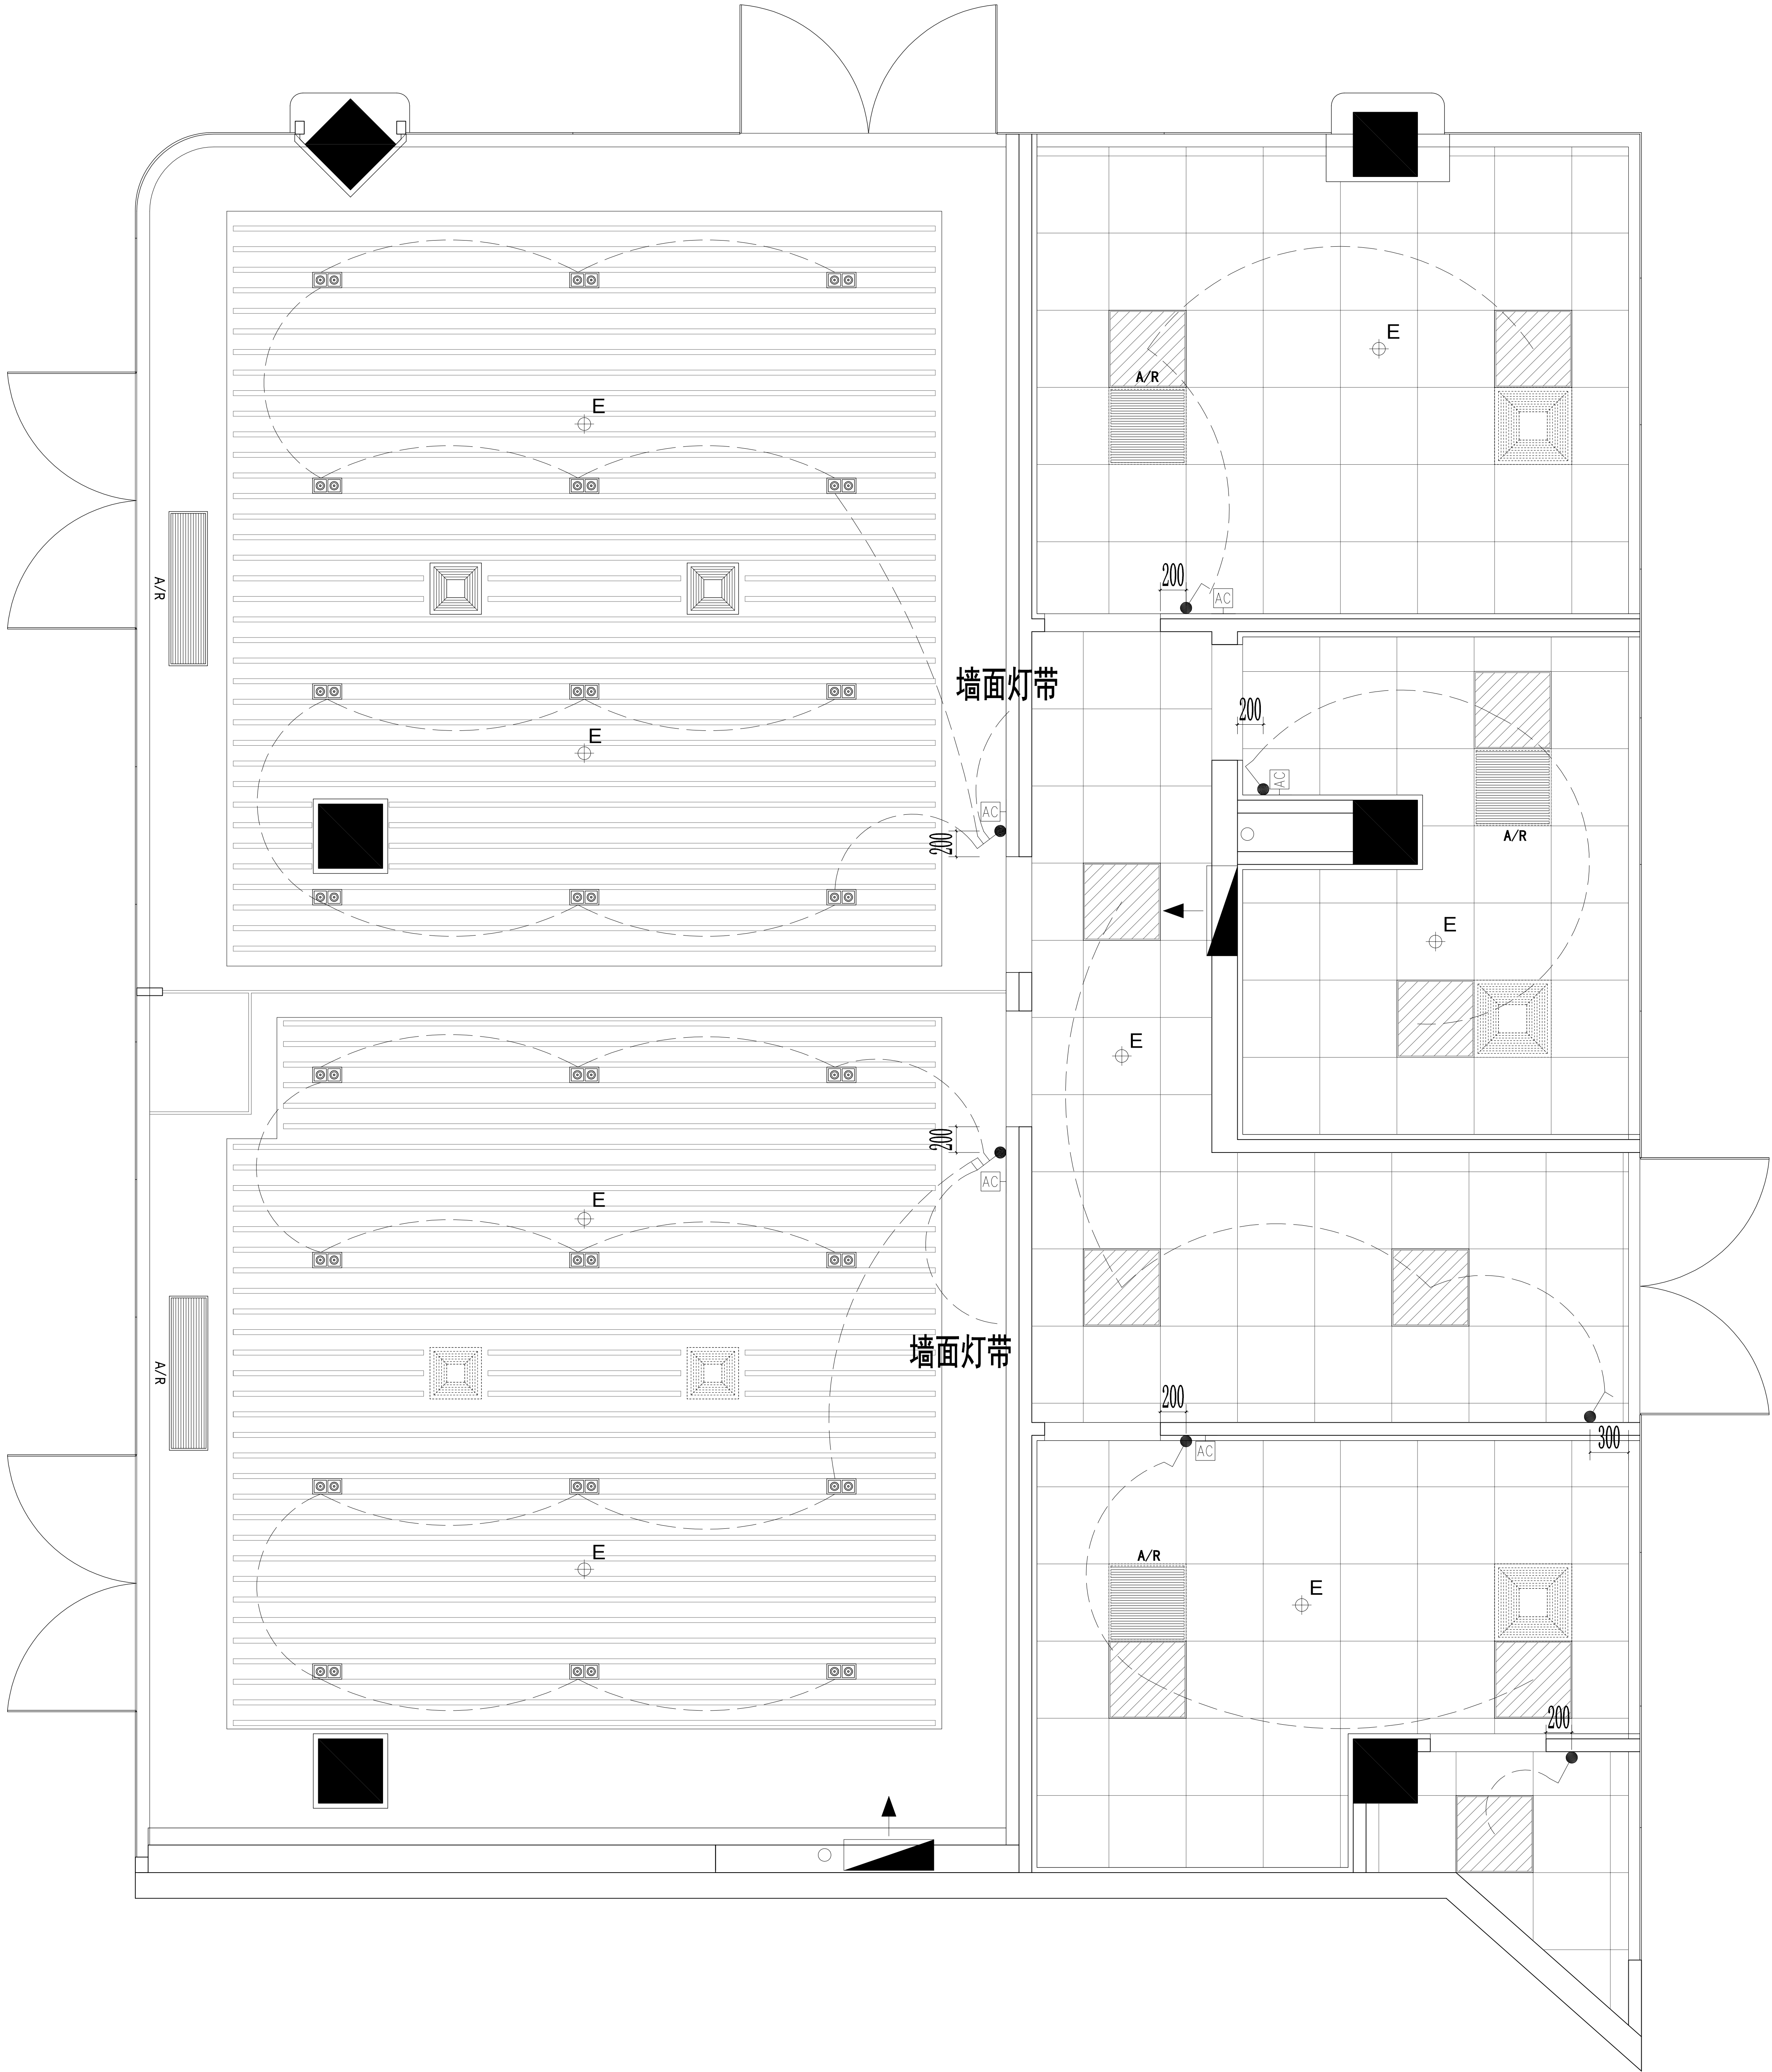

4区 (157m²) 开关连线定位图

ALL DESIGNS AND SPECIFICATIONS ARE THE PROPERTY OF ZI LANG DESIGN LTD. AND CANNOT BE USED WITHOUT THEIR WRITTEN PERMISSION. THE SAME SHALL BE RETURNED UPON COMPLETION OF THE PROJECT. DO NOT SCALE DRAWINGS. ALL MEASUREMENTS MUST BE CHECKED ON SITE BY THE CONTRACTORS AND ANY DISCREPANCIES BROUGHT TO THE ATTENTION OF THE DESIGNER OR ARCHITECT. THIS DRAWING IS TO BE USED FOR THE PROJECT AND SITE IDENTIFIED AND NOT TO BE USED ON ANY OTHER PROJECT.

REVISION DATE

Scale 比例 Date 日期

PH 1:60@A2 PH

Designed BY 设计 Drawn BY 绘图

PH PH

Job NO. 项目编号 APPROVED BY 核准

PH PH

Sheet NO. 图号 页码

4Q-P-10

海门大剧院文化中心商铺装修设计项目

HA IMEN

CHINA


江苏海门市海门大街168号光彩大厦
TEL:0513-82215855 FAX:0513-82215857
http://www.zilang.com
紫浪装饰设计
ZI LANG . DESIGN

插座图示说明	
300	插座高度
W	插座类型
特别标注	
五孔插座	
地插	
网络地插	
网络	
预留接线盒	
天花预留电源	

预留墙面灯带电源
高度H: 1600mm

预留墙面灯带电源
高度H: 1600mm

- 注:
- 所有开关插座位置放样及安装高度以装饰详图为准
 - 弱电由智能化单位二次深化
 - 电气专业详见电气施工图

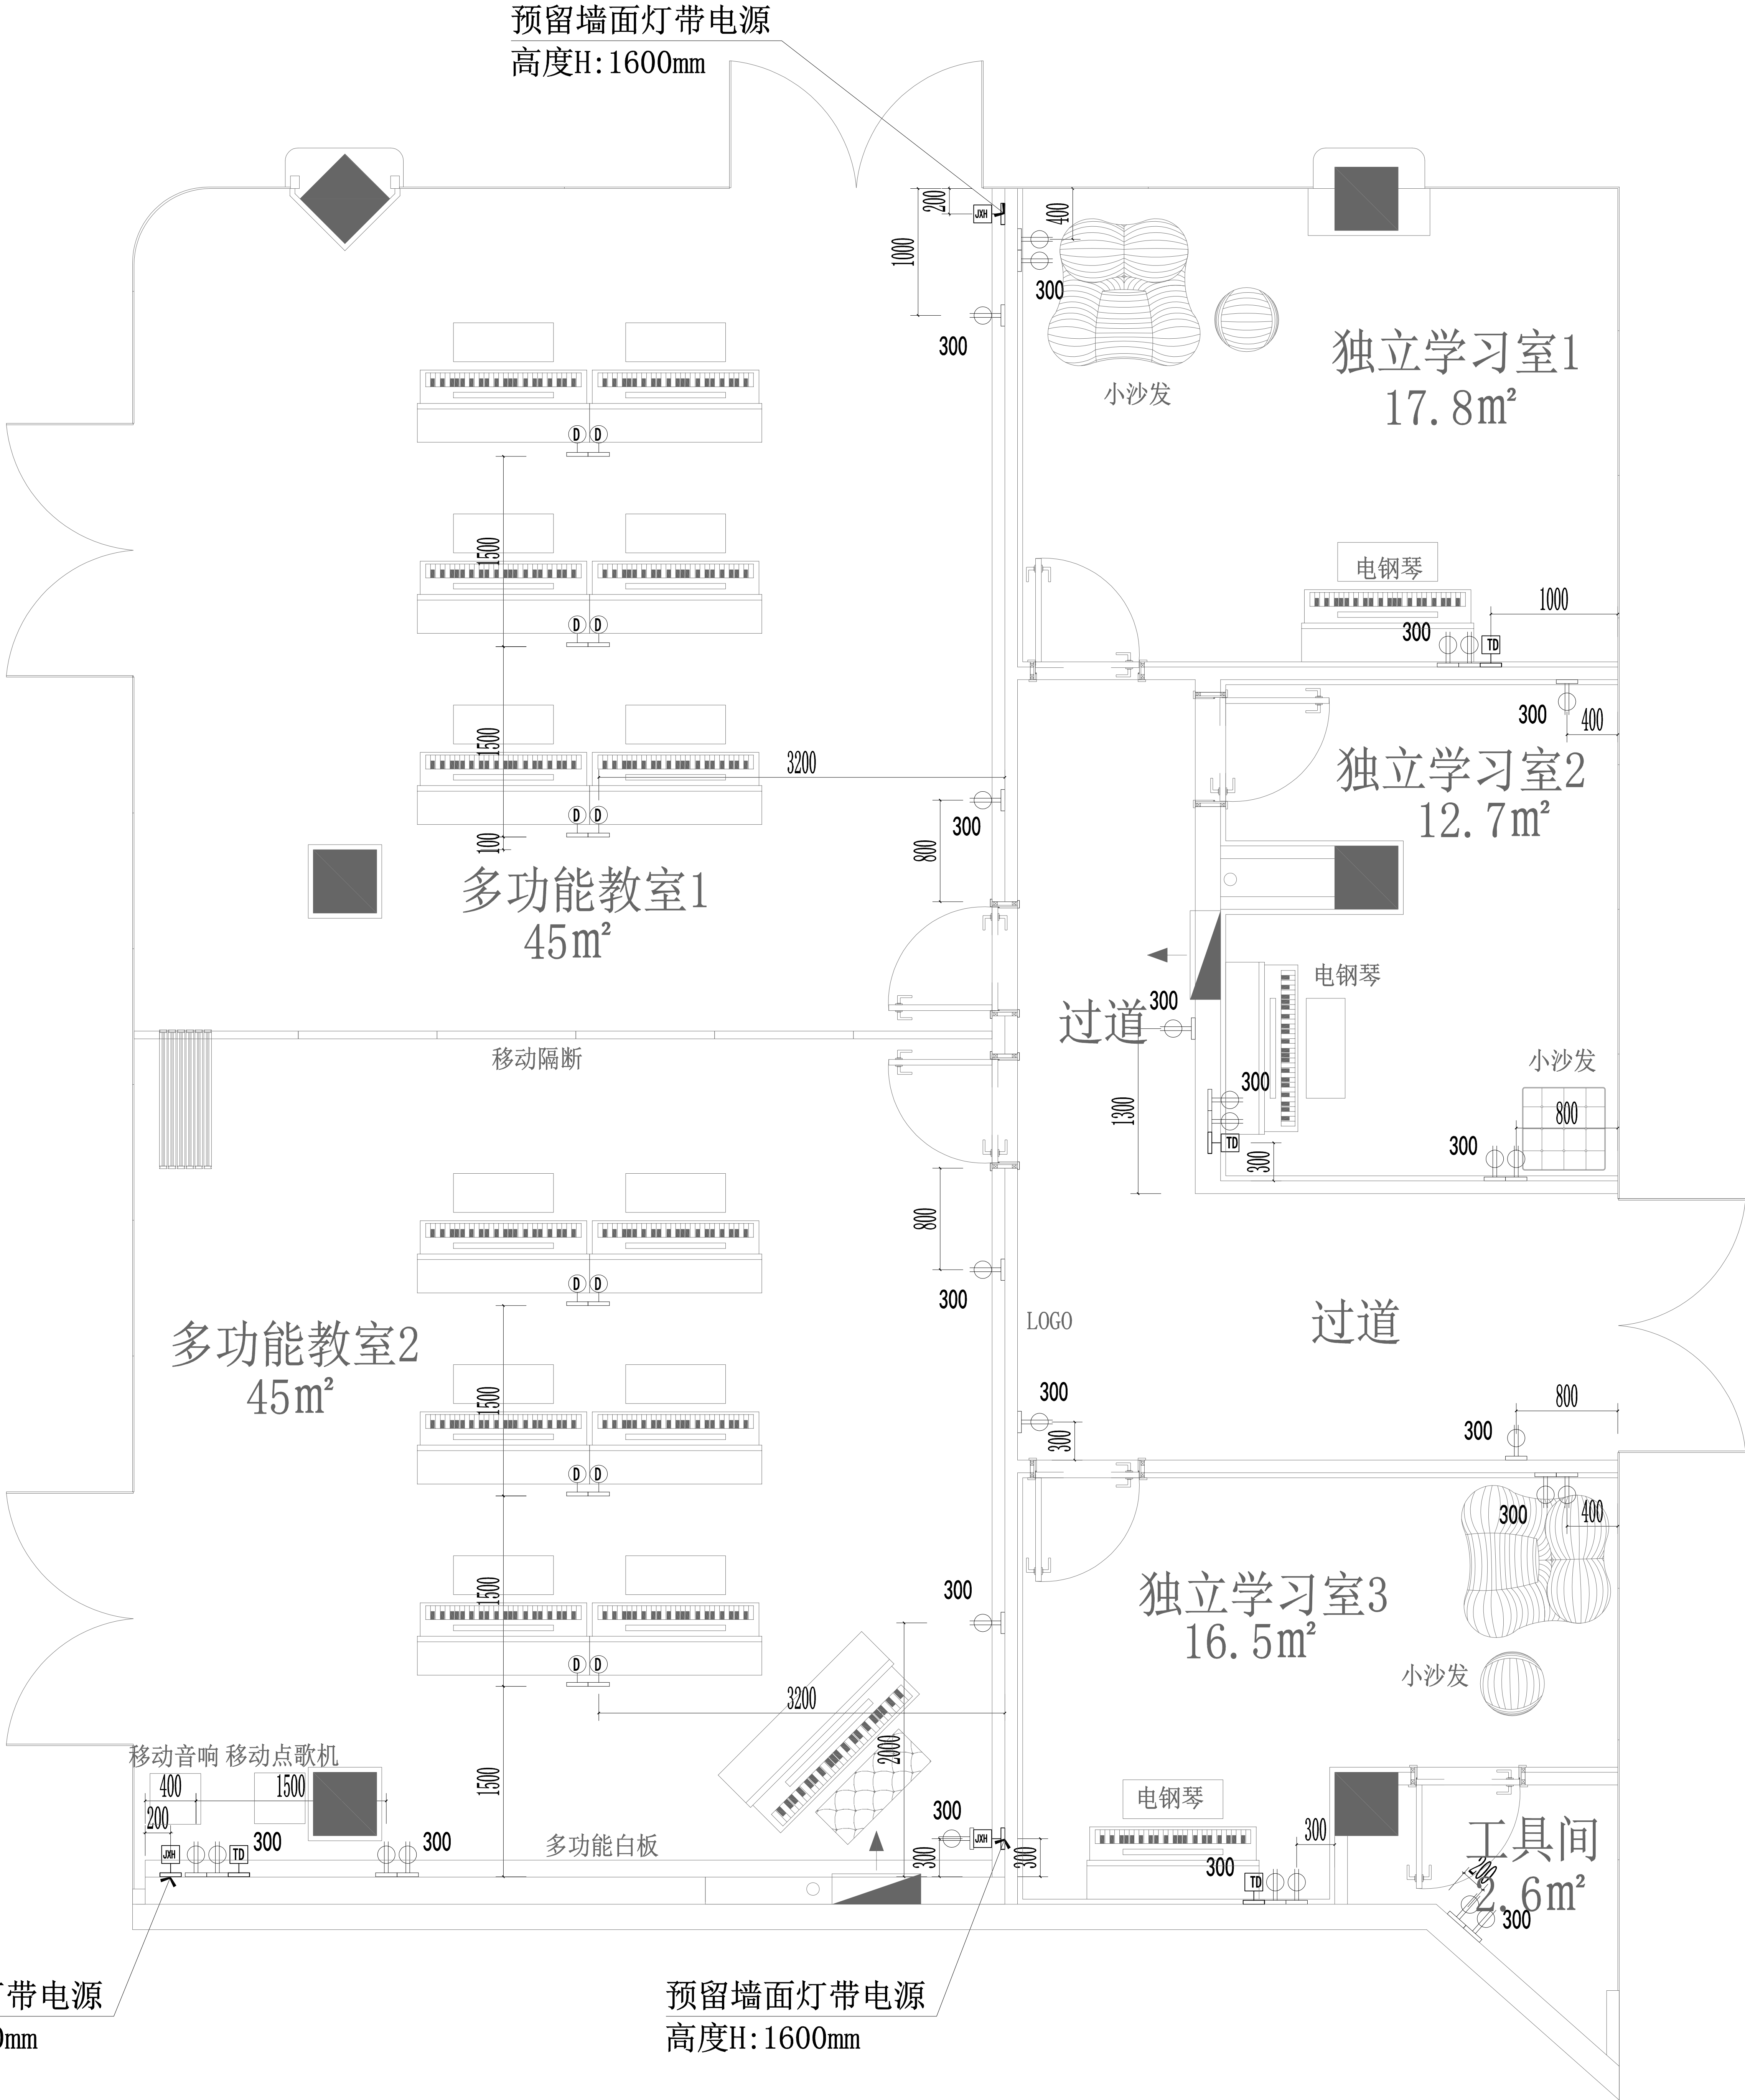


江苏海门市海门路45号光彩大厦
TEL: 0513-86215865 FAX: 0513-86215867
http://www.zilang.com
紫浪装饰设计
ZI LANG . DESIGNED

DRAWING TITLE			
4区 (157m²) 强弱电布置图			
ALL DESIGNS AND SPECIFICATIONS ARE THE PROPERTY OF ZI LANG DESIGN LTD. AND CANNOT BE USED WITHOUT THEIR WRITTEN PERMISSION. THE SAME SHALL BE RETURNED UPON COMPLETION OF THE PROJECT. DO NOT SCALE DRAWINGS. ALL MEASUREMENTS MUST BE CHECKED ON SITE BY THE CONTRACTOR AND ANY DISCREPANCIES BROUGHT TO THE ATTENTION OF THE DESIGNER OR ARCHITECT. THIS DRAWING IS TO BE USED FOR THE PROJECT AND SITE IDENTIFIED AND NOT TO BE USED ON ANY OTHER PROJECT.			
REVISION	DATE		
Scale	比例	Date	日期
1:60	A2		
Designed BY	设计	Drawn BY	绘图
Job NO.	项目编号	APPROVED BY	核准
Sheet NO.	图号		页码
4Q-P-11			

海门大剧院文化中心商铺装修设计项目

HA IMEN CHINA

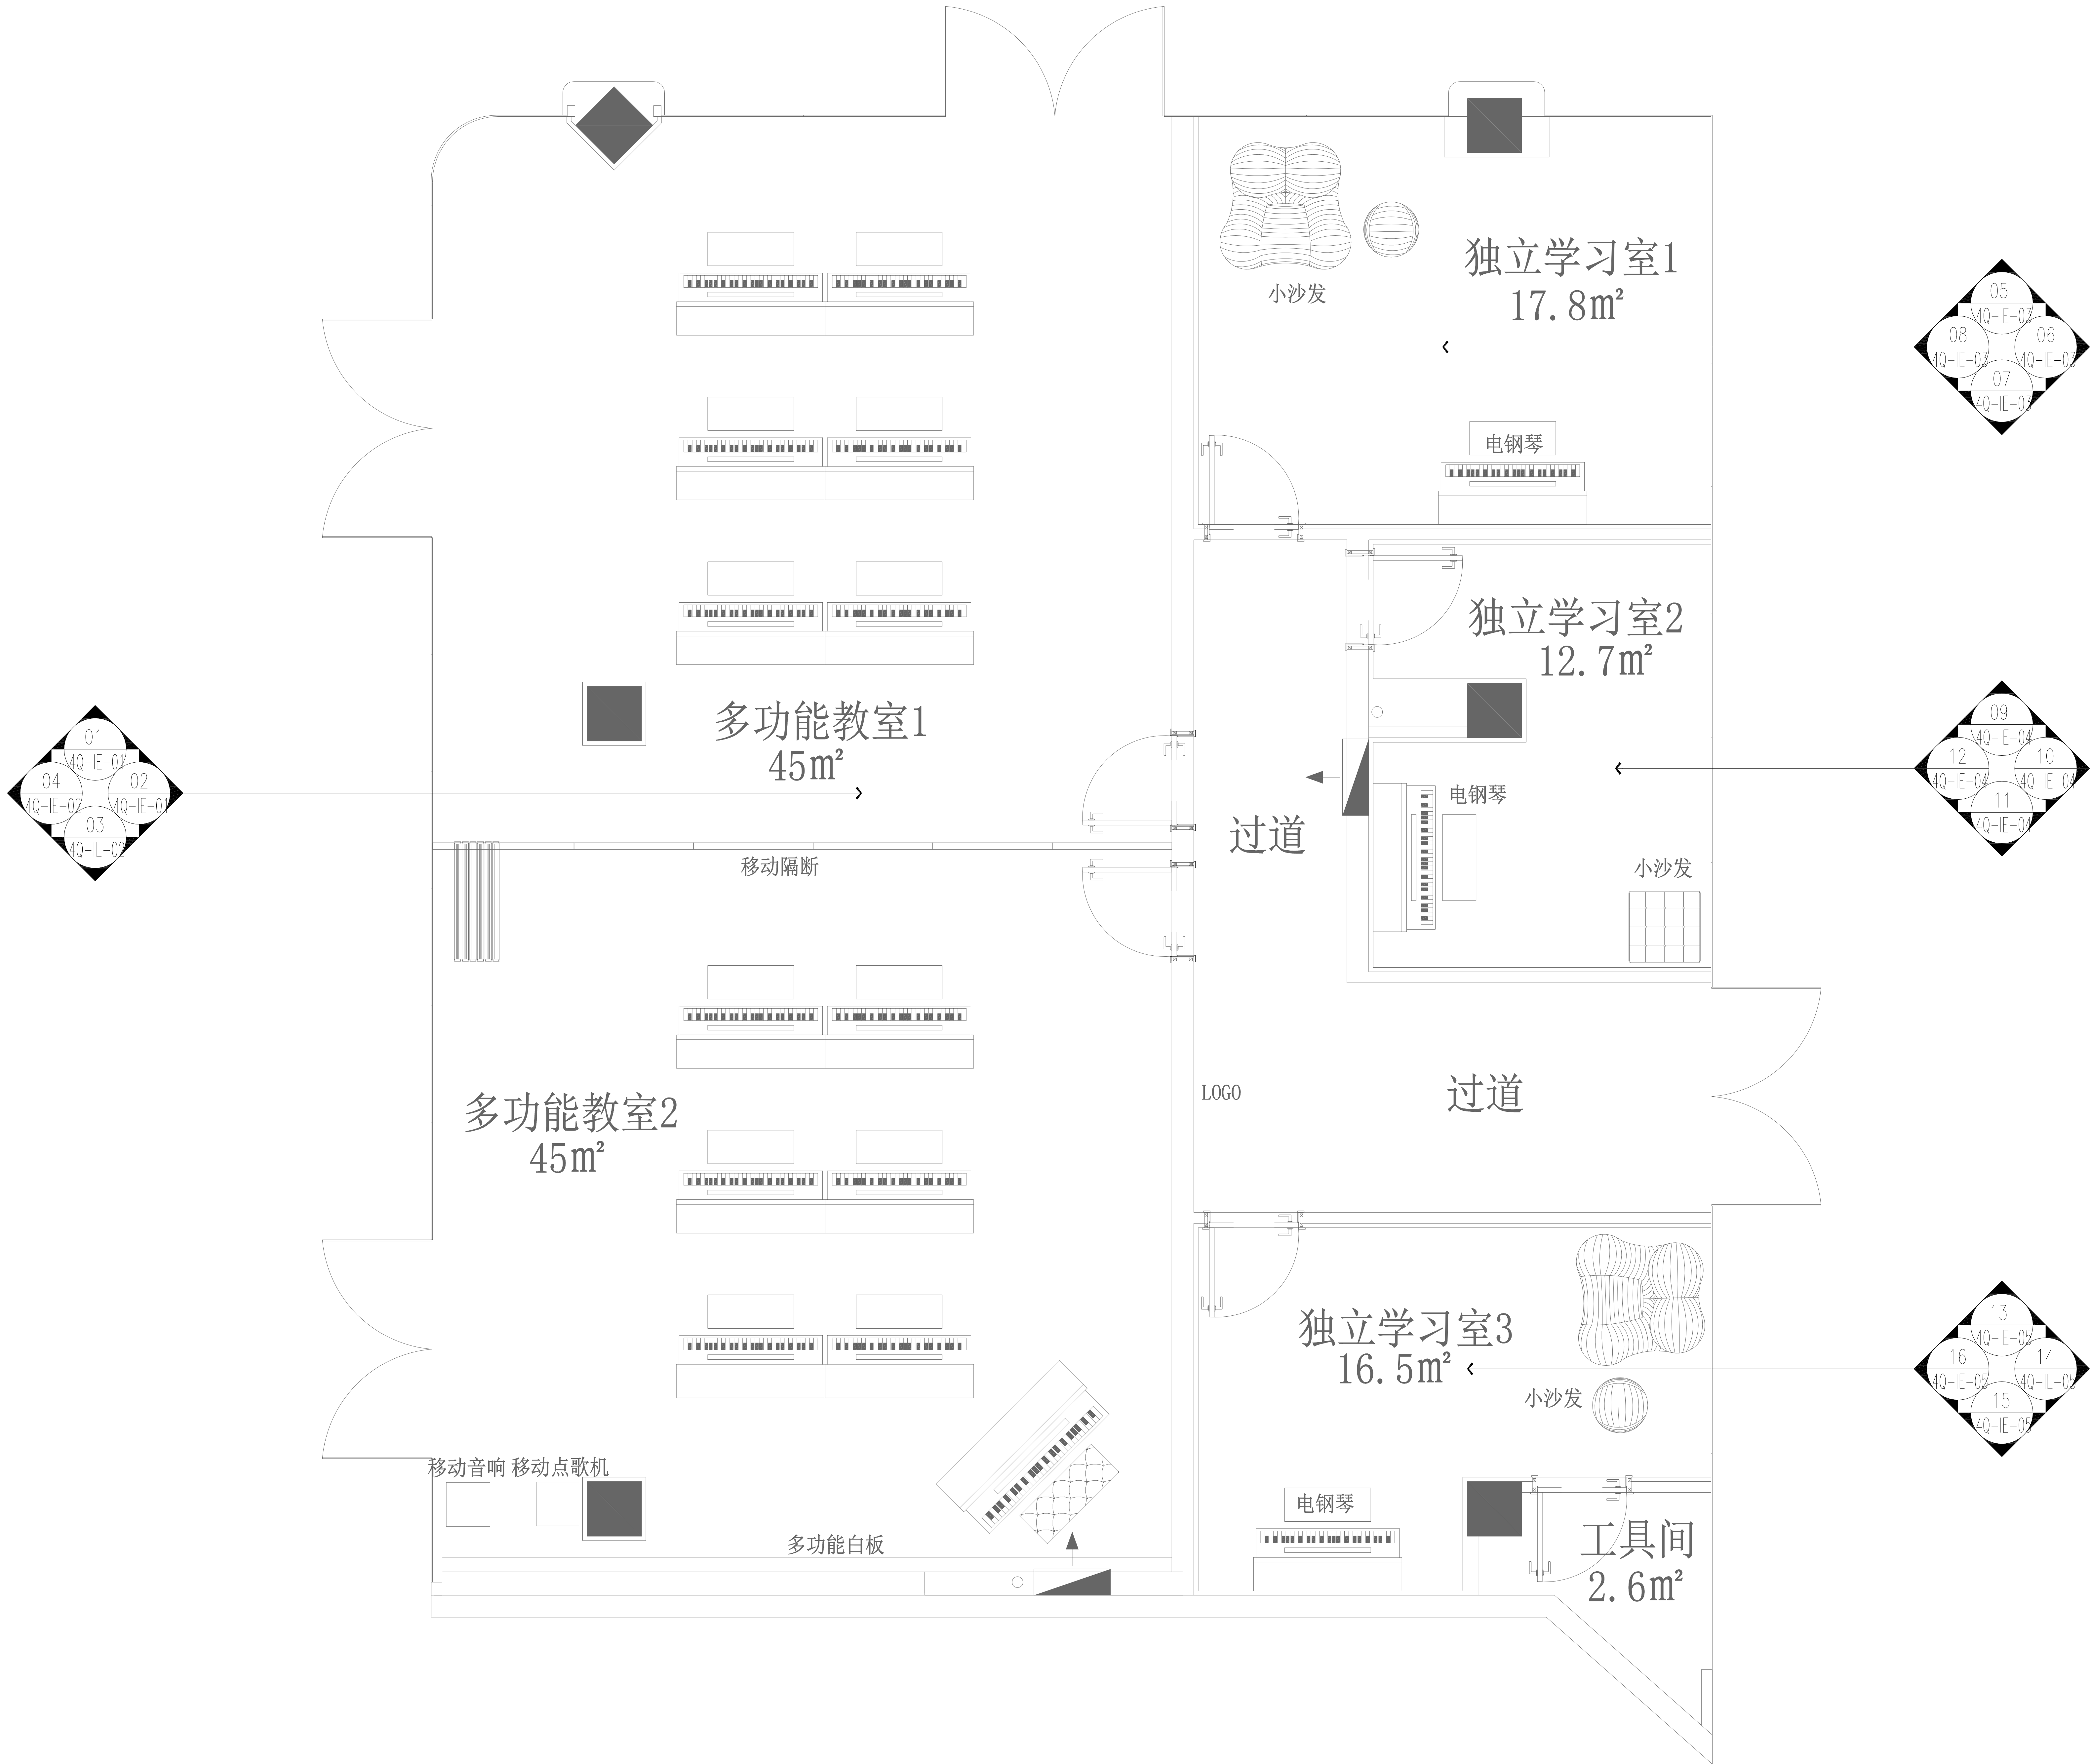

海门大剧院文化中心商铺装修设计项目

CHINA

HAIMEN



ZI LANG

江苏海门市海门路99号海门文化中心
TEL: 0513-86215865 FAX: 0513-86215867
http://www.zilang.com

紫浪装饰设计
ZI LANG . DESIGNED

4区 (157m²) 立面索引图

ALL DESIGNS AND SPECIFICATIONS ARE THE PROPERTY OF ZI LANG DESIGN LTD. AND CANNOT BE USED WITHOUT THEIR WRITTEN PERMISSION. THE SAME SHALL BE RETURNED UPON COMPLETION OF THE PROJECT. DO NOT SCALE DRAWINGS. ALL MEASUREMENTS MUST BE CHECKED ON SITE BY THE CONTRACTORS AND ANY DISCREPANCIES BROUGHT TO THE ATTENTION OF THE DESIGNER OR ARCHITECT. THIS DRAWING IS TO BE USED FOR THE PROJECT AND SITE IDENTIFIED AND NOT TO BE USED ON ANY OTHER PROJECT.

REVISION DATE

Scale 比例 Date 日期

PH 1:60@A2 PH

Designed BY 设计 Drawn BY 绘图

PH PH

Job NO. 项目编号 APPROVED BY 核准

PH PH

Sheet NO. 图号 页码

4Q-P-12